



UPDATED: Wednesday, November 13, 2013 9:44:40 AM BY: Manual

PRINTED: Monday, January 20, 2014 9:15:31 AM DWG NAME: H:\PROJECTS New NOS\Design Drafting\General\DFR\PI\PI-0013 Rev 03.dwg

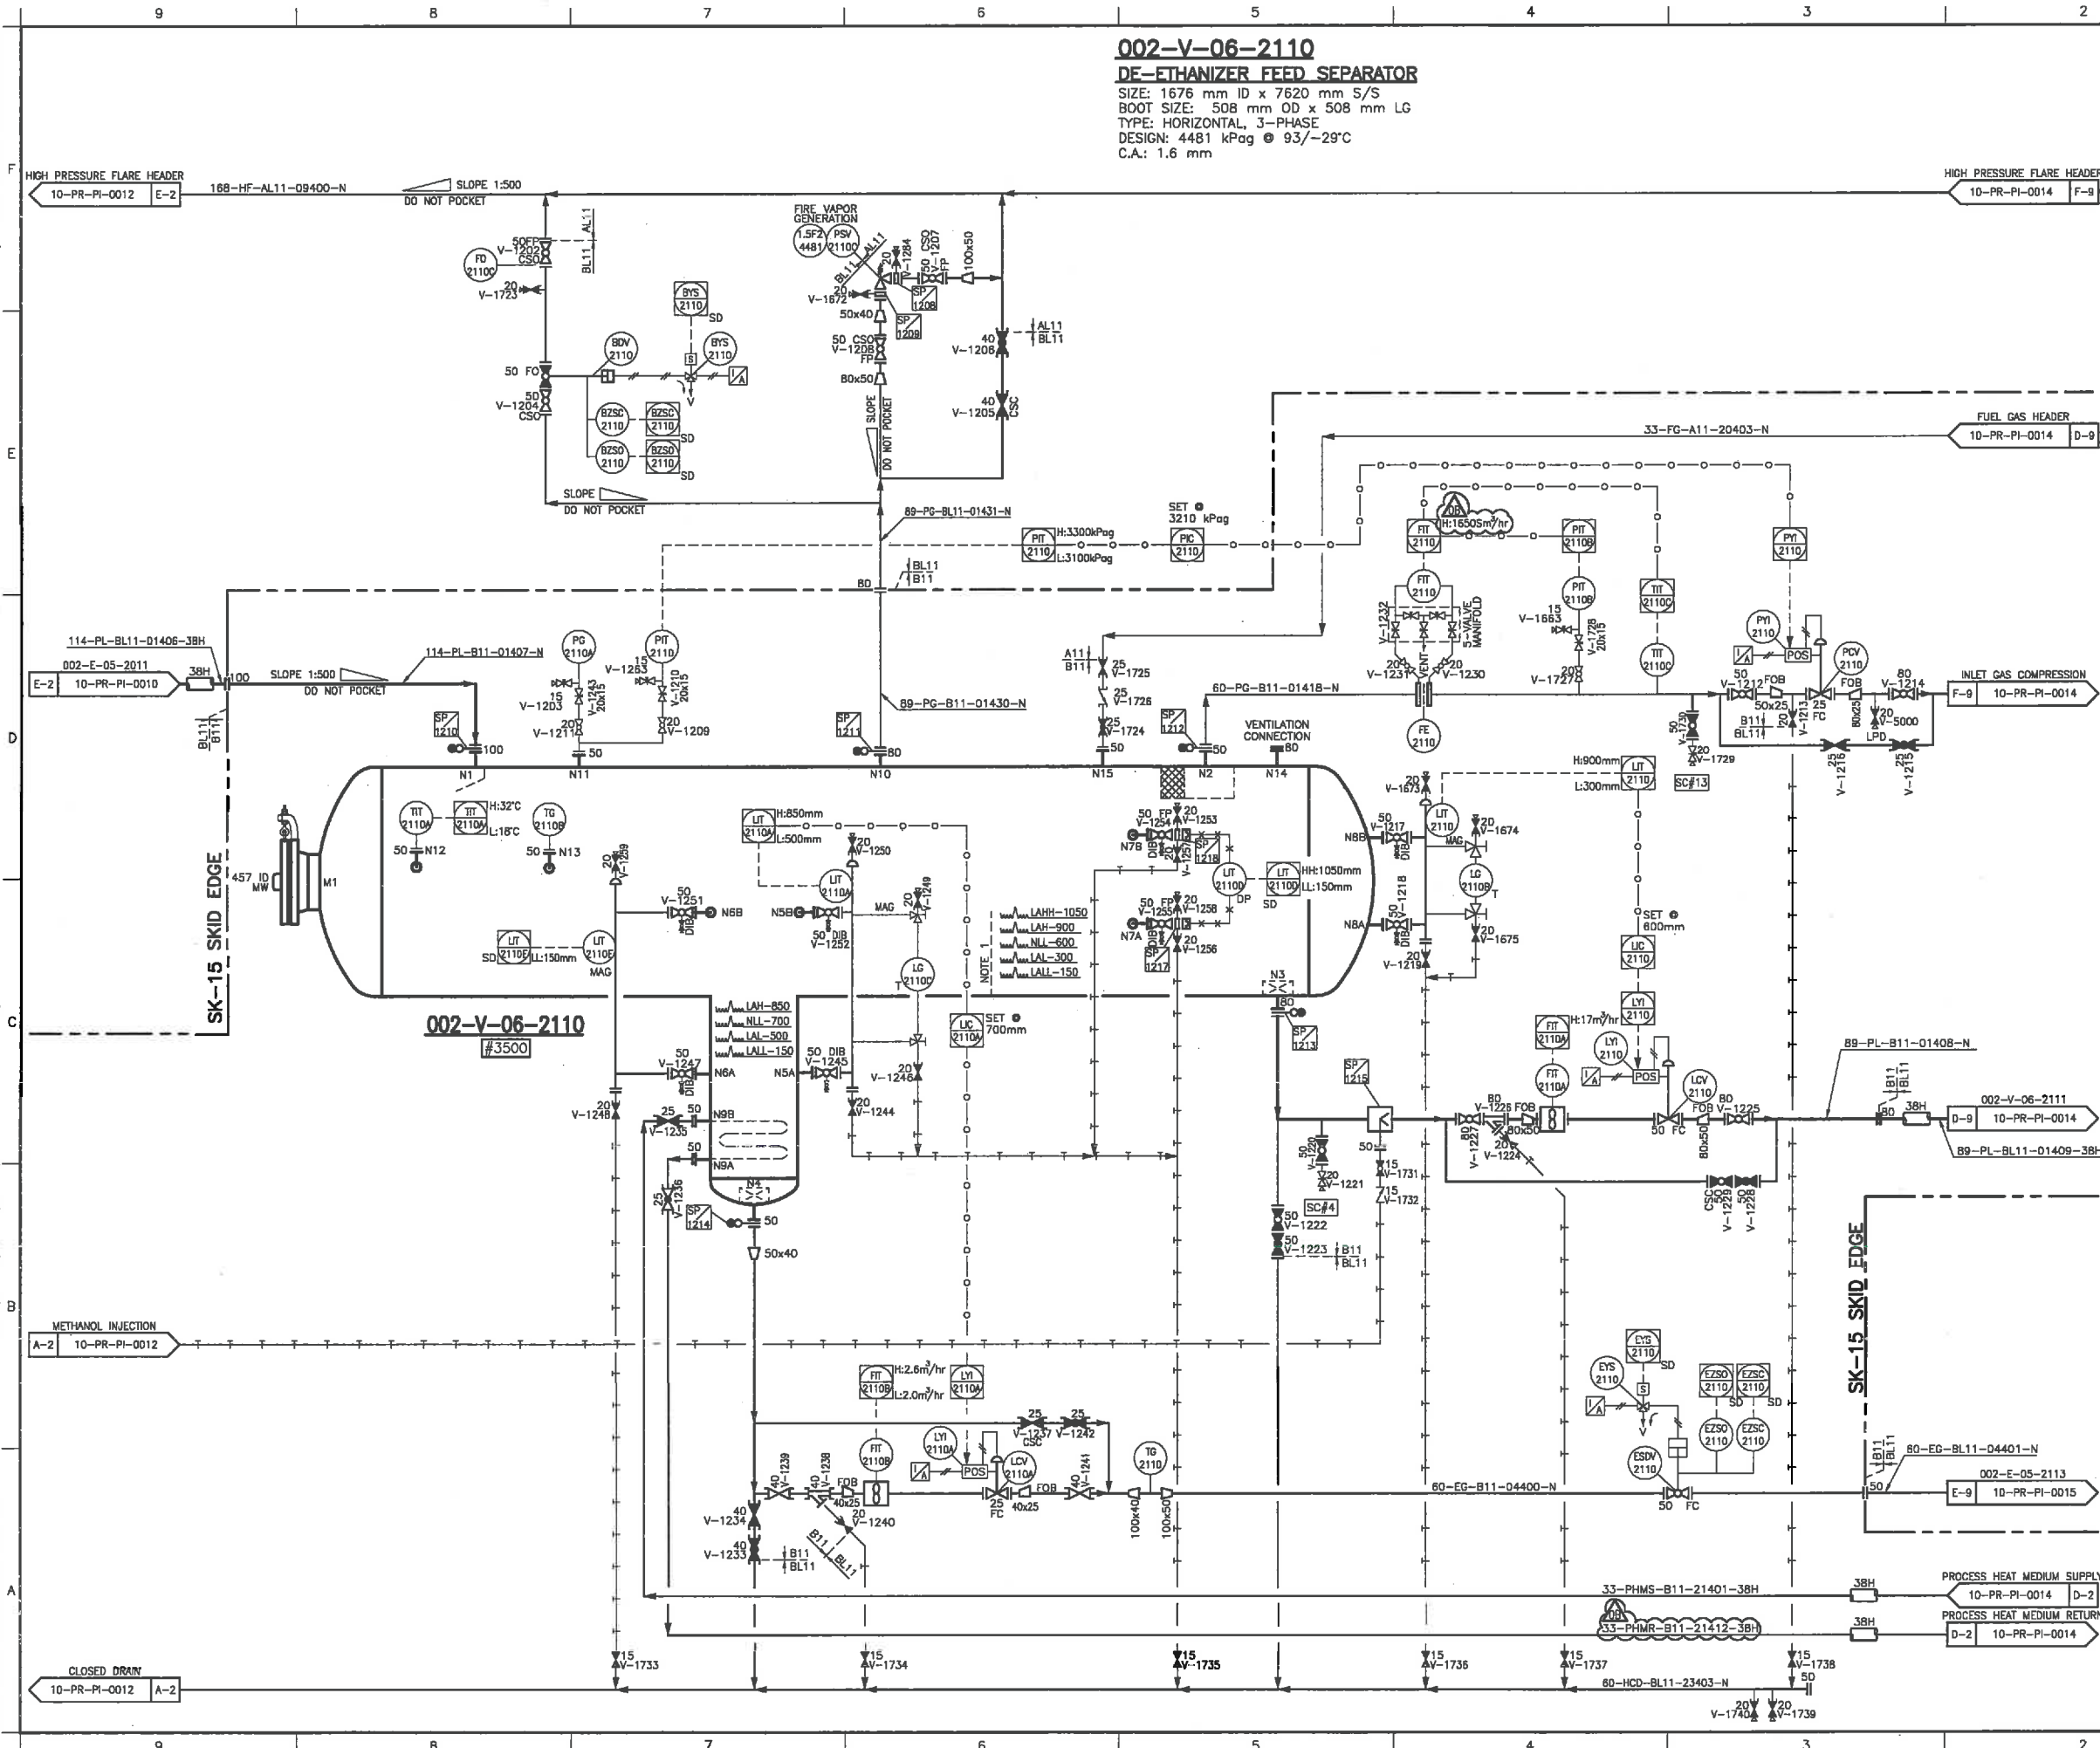

GENERAL NOTES:

1. ADJUSTABLE WEIR.
2. LOW POINT DRAINS/HIGH POINT VENTS ADDED WHERE REQUIRED.
3. ALL INTERCONNECTING PIPING WITHIN SHALLOWCUT BATTERY LIMIT IS BY TDE.
4. ALL INSTRUMENTS SYMBOLS ON THIS PID TO BE PREFIXED BY 06.

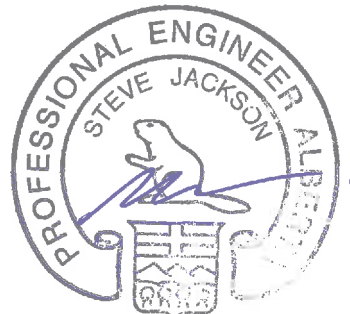

OB	REVISED AS MARKED	NOV.06/13	MFF
DA	REVISED AS MARKED	OCT.02/13	SSE
O	RELEASED FOR FABRICATION	JUL.17/13	MFF
NO.	REVISION	DATE	BY
PROJECT NAME:			
FERRIER CENTRAL PROCESSING FACILITY			
CLIENT:			
DEVON CANADA c/o WORLEY PARSONS			
DOCUMENT NAME:			
DE-ETHANIZER FEED SEPARATOR PIPING AND INSTRUMENTATION DIAGRAM			
TDE Thermal Design Engineering Ltd.			
12-118			
DFR-10-PR-PI-0013			