


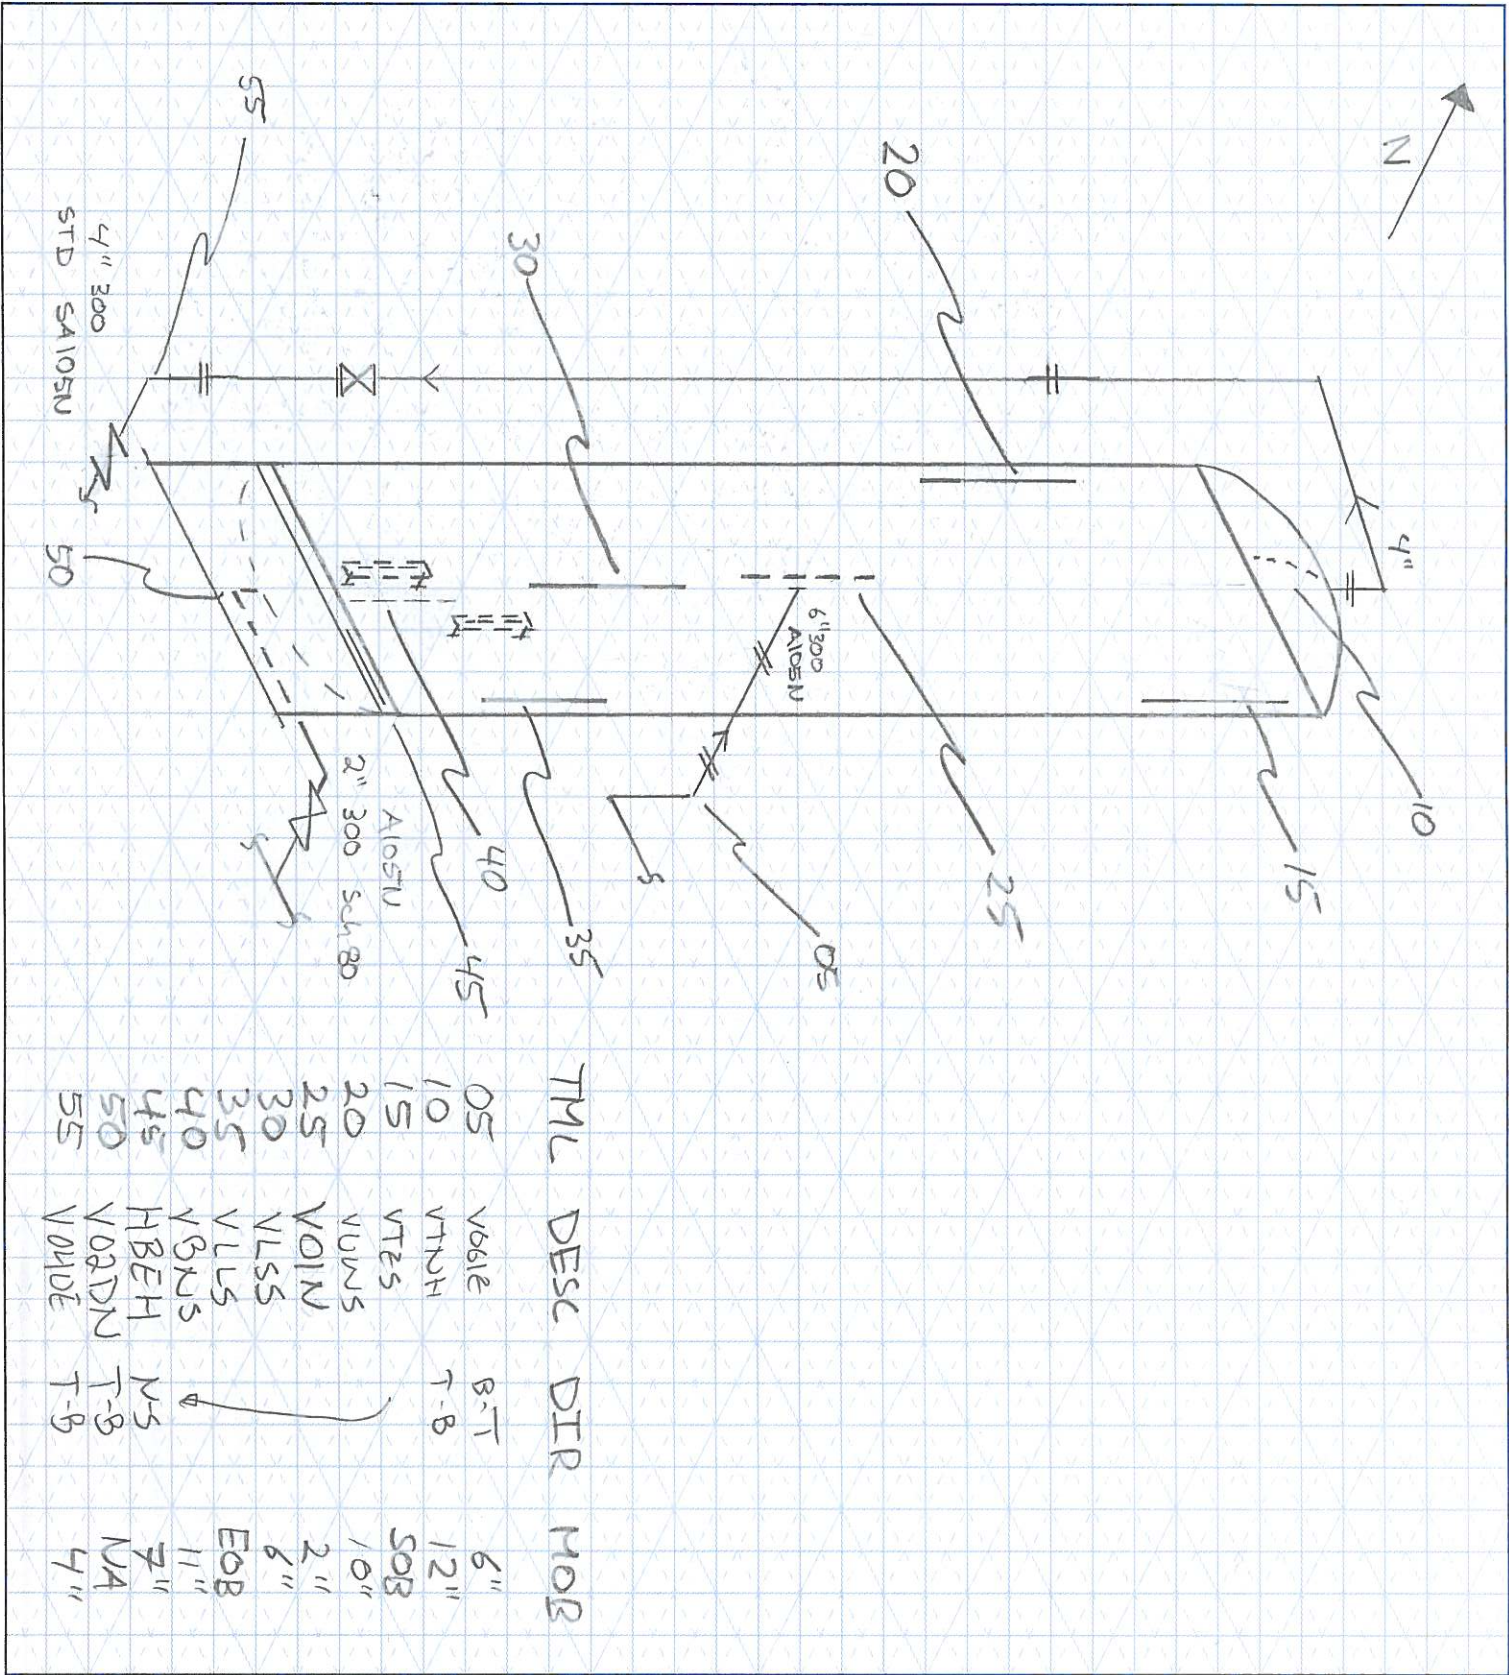

CUSTOMER:	CNRI	FACILITY:	Cherhill Comp Strn	LSID:	15-08-057-05-WSM
P & ID:		DRAWN BY:	Mikael	DATE:	04-21-10
DRAWING NO. 123812-MF-06					
VESSEL DESCRIPTION: Inlet Separator					
Equip. No.	Pro.Reg.No (A)	C.R.N.	L-0404.2	Serial No	97168 B
Code/Div.	Size:	ID / OD X	Manufacturer:	Yr. Inst.	Yr. Blt.
C. Stamp	Service:	PWHT:	J.E.:	Radiography:	Insulated:
HEAD:					
Top Mat'l	Top Nom	Top C.A.	Material	Nominal	C.A.
Btm Mat'l	Btm Nom.	Btm C.A.	MDMT	@Temp	
BOOT:					
Head Mat'l	Head Nom	Head C.A.	Top Mat'l	Top Nom.	Top C.A.
Shell Mat'l	Shell Nom.	Shell C.A.	Btm Mat'l	Btm Nom.	Btm C.A.
MAWP Shell side:	@ Temp.	MAWP Tube Side:	@ Temp.		
PIPING INFORMATION:					
Circuit. No.	Line No. (s) (PLEASE PUT LINE NUMBERS ON APPLICABLE LINES ON THE DRAWING)				
Piping Class	Service:	Yr. Blt.			
MAWP:	@ Temp.	Size & Schedule of Piping	(PLEASE PUT APPROPRIATE SIZES AND SCHEDULES OF PIPING ON DRAWING)		

A0419464 UT Readings
Readings in inches

	MIN	MAX	AVG
LOC 5	0.244	0.277	0.251
LOC 10	0.835	0.92	0.876
LOC 15	0.881	0.888	0.885
LOC 20	0.892	0.897	0.894
LOC 25	0.892	0.901	0.894
LOC 30	0.892	0.897	0.895
LOC 35	0.885	0.89	0.887
LOC 40	0.885	0.893	0.887
LOC 45	0.855	0.935	0.898
LOC 50	Obstr	Obstr	Obstr
LOC 55	0.222	0.25	0.238