
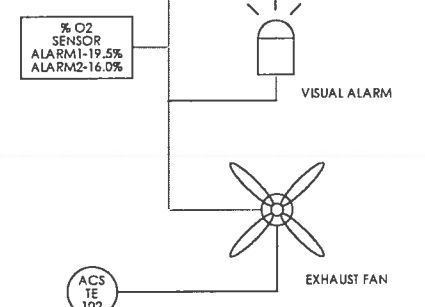


REVISIONS		
REV.	ECN#	DESCRIPTION
1		ENGINEERING PRE-RELEASE
2		DRAWING REVISED

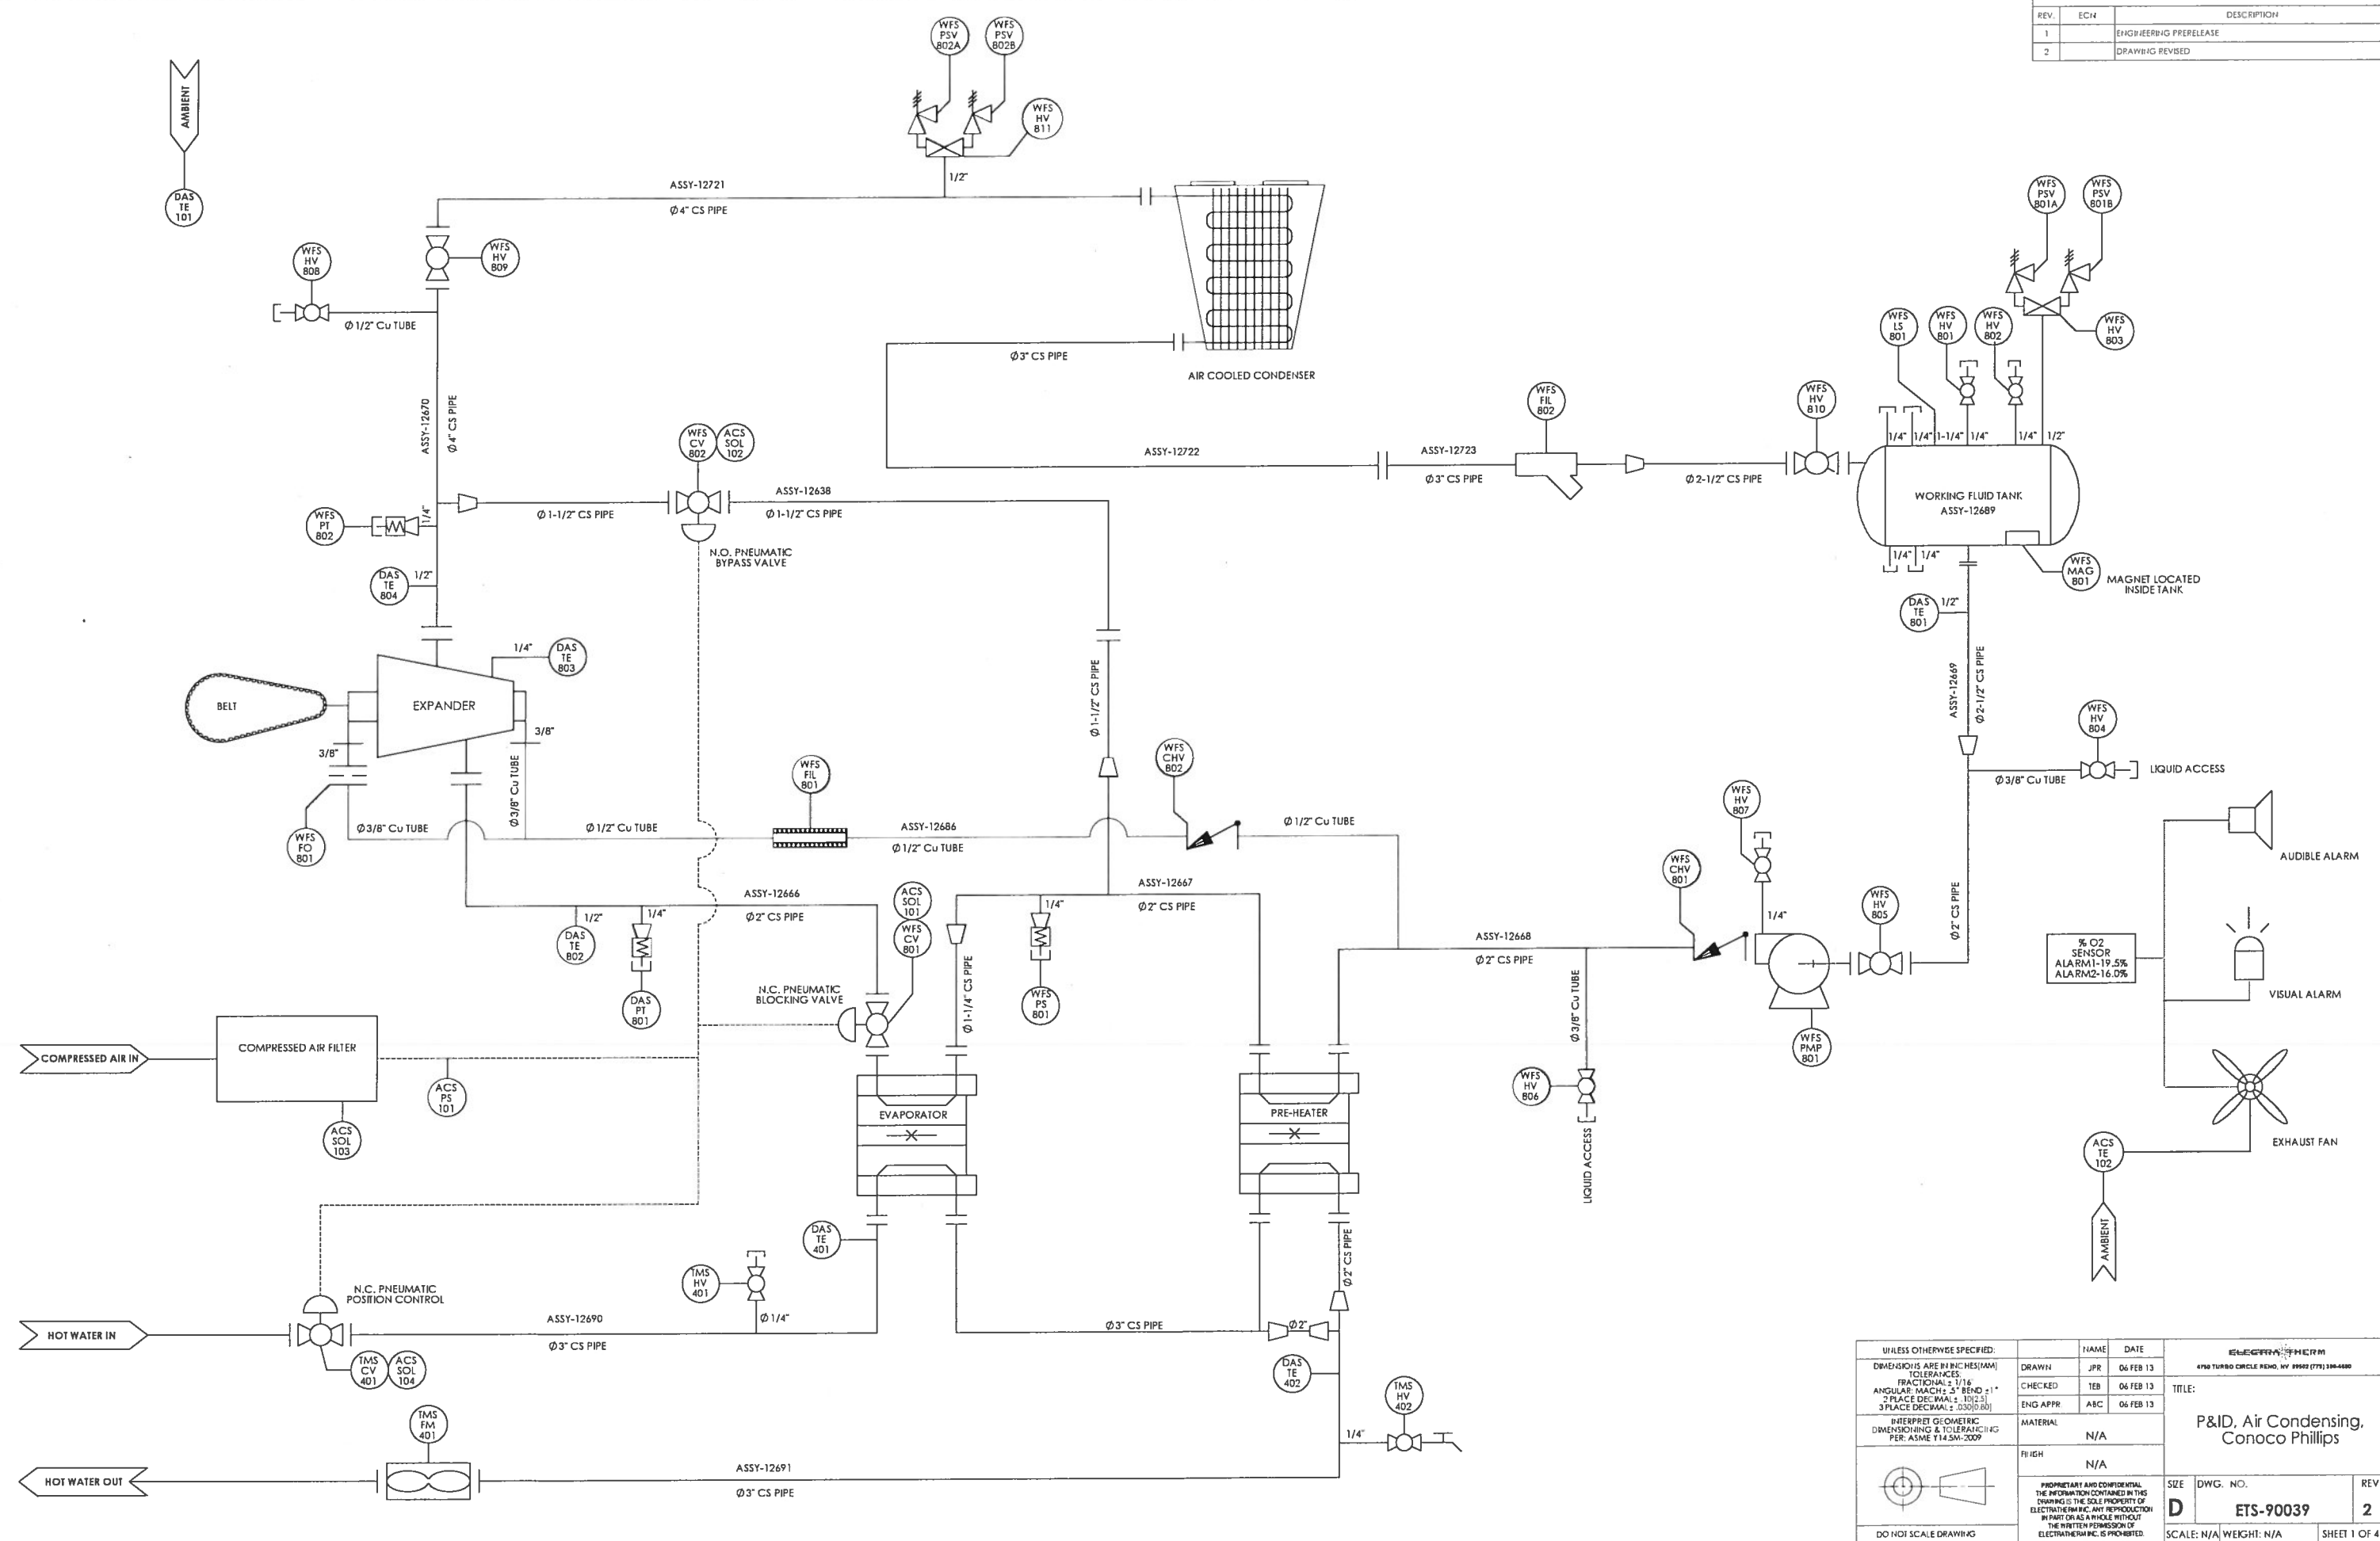

UNLESS OTHERWISE SPECIFIED: DIMENSIONS ARE IN INCHES (MM) TOLERANCES: FRACTIONAL ± 1/16" ANGULAR: MACH ± 5° BEND ± 1° 2 PLACE DECIMAL ± .005 (± .01) 3 PLACE DECIMAL ± .0005 (± .001)	NAME	DATE	TITLE: <b>P&amp;ID, Air Condensing,          Conoco Phillips</b>
	DRAWN	06 FEB 13	
	CHECKED	06 FEB 13	
	ENG APPR	06 FEB 13	
INTERPRET GEOMETRIC DIMENSIONING & TOLERANCING PER: ASME Y14.5M-2009	MATERIAL	N/A	PROPRIETARY AND CONFIDENTIAL THE INFORMATION CONTAINED IN THIS DRAWING IS THE SOLE PROPERTY OF ELECTRA-THERM, INC. ANY REPRODUCTION IN PART OR AS A WHOLE WITHOUT THE WRITTEN PERMISSION OF ELECTRA-THERM, INC. IS PROHIBITED.
FINISH	N/A		
	SIZE	DWG. NO.	REV
DO NOT SCALE DRAWING	<b>D</b>	<b>ETS-90039</b>	<b>2</b>
	SCALE: N/A	WEIGHT: N/A	SHEET 1 OF 4

D ETS-90039 REV 2