




AREA LIMIT N. 0+23.500

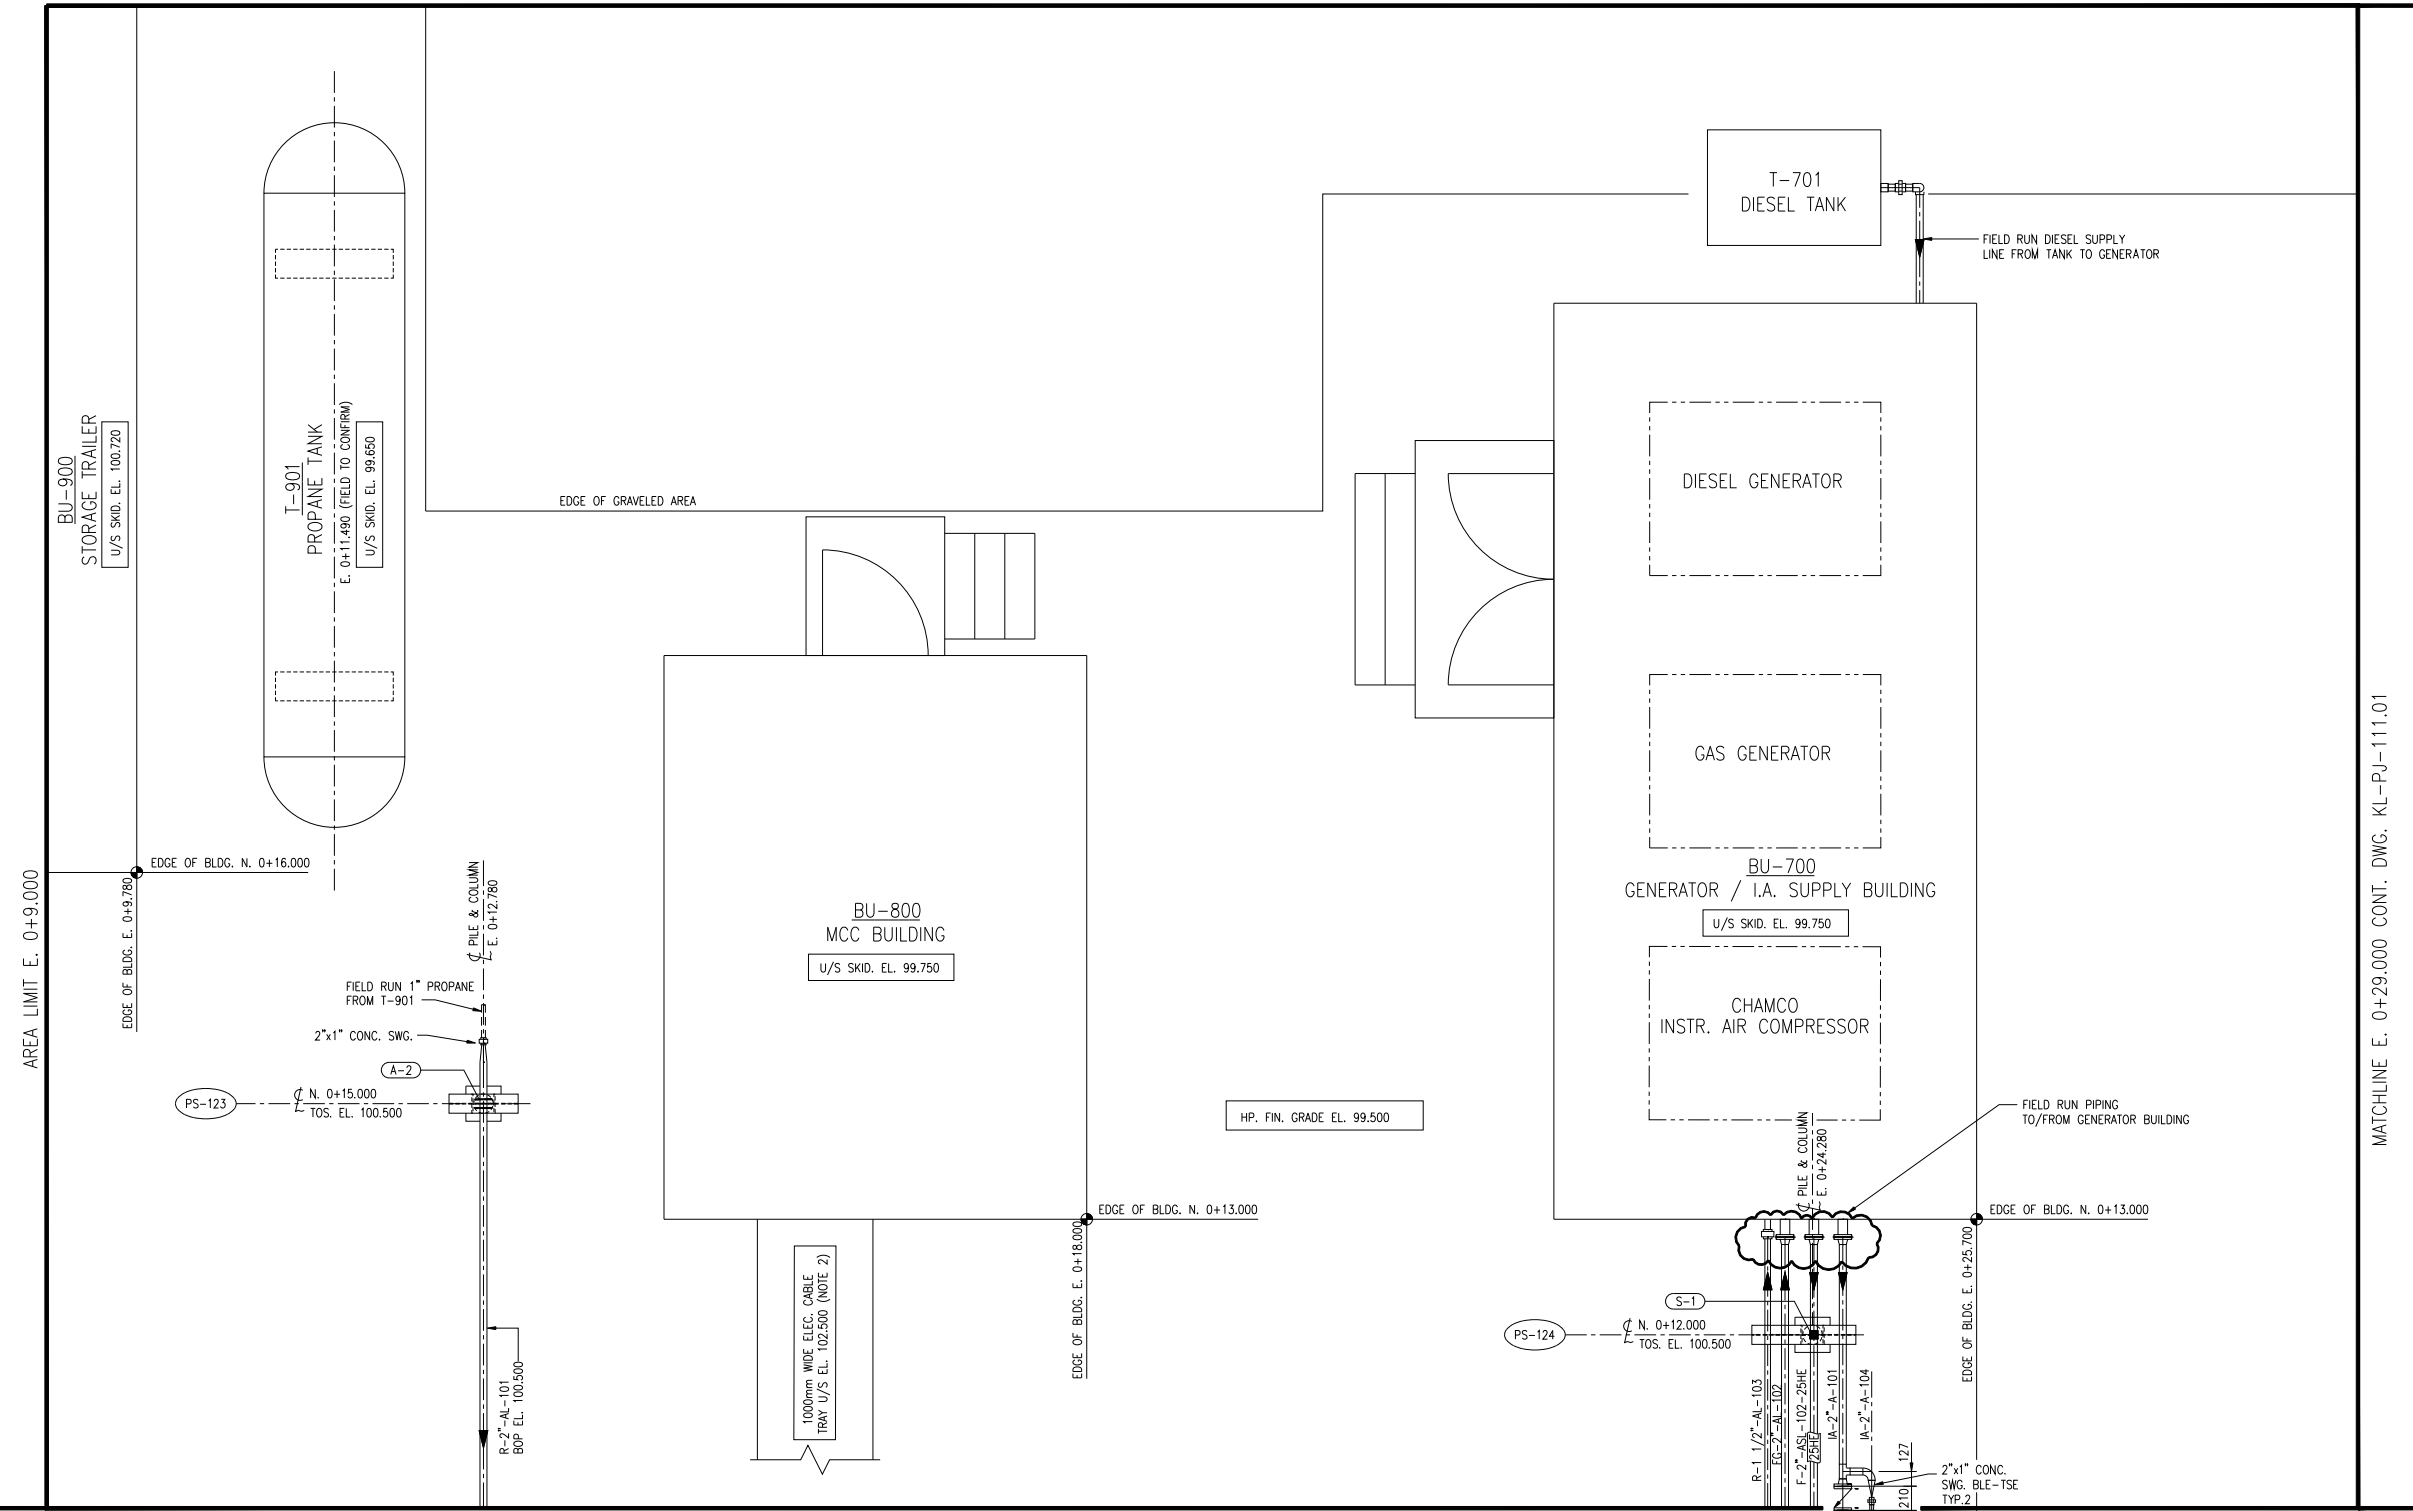

AREA LIMIT E. 0+9.000

MATCHLINE E. 0+29.000 CONT. DWG. KL-PJ-111.01

MATCHLINE E. 0+10.500 CONT. DWG. KL-PJ-103.01

NOT AS-BUILT FOR PROJECT NO. 5583

NOTES:  
 1) HYDROTEST VENTS & DRAINS BY MECHANICAL CONTRACTOR.  
 2) CABLE TRAY SIZE & ROUTING BY OTHERS. SHOWN FOR REFERENCE ONLY.

KL-PG-103.01	KEY PLAN							
KL-PA-115.01	PLOT PLAN							
NUMBER	TITLE	0	ISSUED FOR CONSTRUCTION	HMH	03.03.04			
REFERENCE DRAWINGS		NO	REVISION	BY	DATE	CKD	APP	

PERMIT STAMP

ENGINEER'S STAMP

**DPH ENGINEERING INC.**

DRAWN	CHECKED	APPROVED DSGN. ENG.	APPROVED PROJ. ENG.
BY DFP			
DATE 03.01.16			

DPH PROJECT No. 5583 DWG. SIZE A1 (594x841)

**Anadarko**  
Canada Corporation

ADSETT SATELLITE GAS COMPRESSION PIPING PLAN  
MCC / GEN. SET BLDG. AREA

SCALE 1:30	DRAWING NUMBER KL-PJ-110.01	REV 0
------------	-----------------------------	-------

May 27, 2003, 8:17:57 a.m.  
 Drawing: G:\CAD\095\5583\ASBUILT\MECH\PIPING\A1\11001.DWG  
 xrefs: bc-wp.dwg

DPHAT-M