


T-140
COMP. LUBE OIL TANK

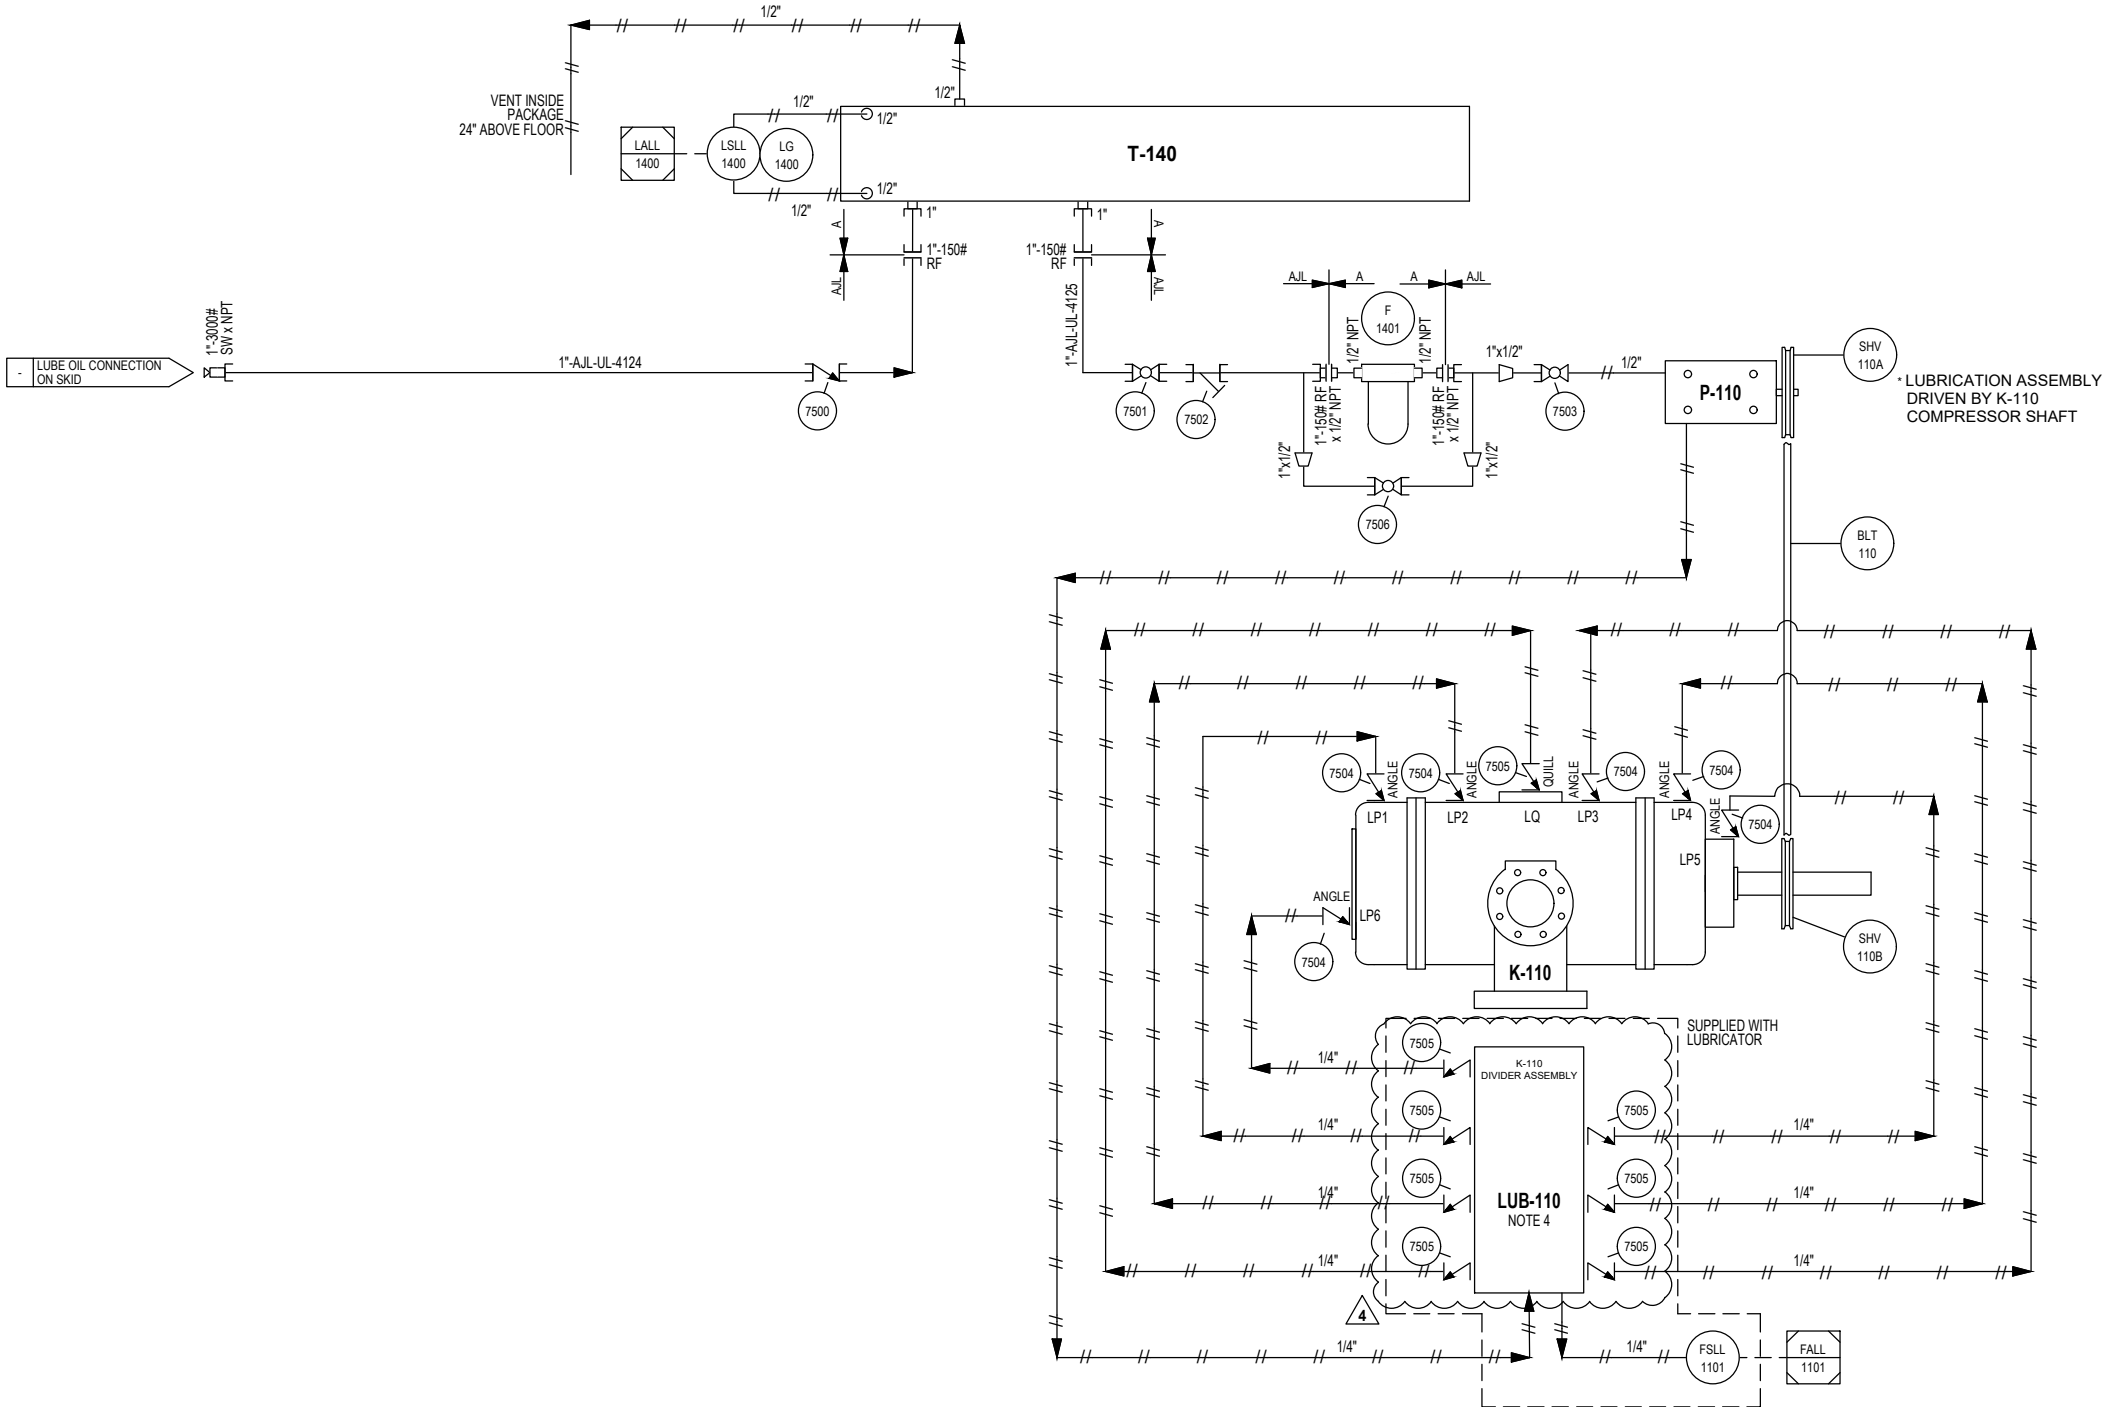

APPROVED
By Kevin Huartson at 10:41 am, Nov 20, 2023

1. ALL

2. REFER TO CNRL PIPING SPEC. FOR RADIOGRAPHY REQ'S & MATERIALS.
3. ELECTRICAL CLASSIFICATION: CSA CLASS 1, ZONE 2, GROUP IIA.
4. SET LUBRICATOR FLOW RATE AS FOLLOWS:
A - INITIAL 300 HR BREAK-IN PERIOD: 10.66 PINTS/DAY.
B - NORMAL OPERATION: 5.33 PINTS/DAY.

REVISIONS				
REV	DESCRIPTION	DATE	BY	APPR
A	ISSUED FOR HAZOP	3/8/23	RR	KH
B	ISSUED FOR APPROVAL	3/30/23	RR	KH
0	ISSUED FOR CONSTRUCTION	5/26/23	RR	KH
1	UPDATED COUPLING TAG, UPDATED CODE	6/21/23	RR	KH
2	UPDATED BALLOON TAGS	8/11/23	RR	KH
3	ADDED TUBING SIZES, LUBE OIL CONTENT, PIPING LAYOUT	9/29/23	RR	KH
4	QUILL REFERENCE REMOVED	11/20/23	RR	KH



TITLE: COMPRESSOR UTILITIES			
PROJECT: CANADIAN NATURAL RESOURCES LTD			
VRU ROFLO 60 HP ELECTRIC SMITH, ALBERTA - LSD: TBA			
ENG. BY: K.HUARTSON		PROJECT NO: 101121/2/3/4/5/6/7	
DRAWN BY: R.ROVETO		CLIENT REF. NO:	
DRAWN DATE (MM/DD/YY): 02/07/23	SHEET: 1 OF 1	DRAWING NO: 101121-7500	REV: 4