


P-113 JACKET WATER PUMP VIKING GG4195 CAPACITY: DISCH. PRESS: 1724 kPag (250 PSI) MAX. INTERNAL RELIEF ≤ 207 kPag (30 psig) BELT DRIVEN	E-114 JACKET WATER COOLER AKG THERMAL AX-30 DUTY: 8.7 kW	EM-114 JW COOLER MOTOR BALDOR RELIANCE DUTY: 0.4 kW (1/2 HP), 1800 RPM SUPPLY: 230/460VAC, 3PH, 60 Hz	T-114 SURGE TANK CAPACITY: 11 L (3 GAL) RATING: 48 kPag (7 PSIG PRESS.) VENT CAP T-111 LUBE OIL TANK CAPACITY: 0.25 m³ (65 GAL) RATING: AMBIENT	P-112 LUBRICATOR SLOAN SLS-4M-LE C/W 1 DIRECT FEED PUMP, 1/4" PISTON BELT DRIVEN	FL-112 LUBE OIL FILTERS MODEL: HASTINGS HF732 RATING: 25 MICRON	BH1102/1103 BUILDING HEATER RUFFNECK MODEL: FX6-480360-075T RATING: 25,600 btu/hr, 7.5 kW, 3 PH 16.4 AMP	EF-1101A/B EXHAUST FANS ENERTECH MODEL: ET-12 POWER: 0.4 kW (1/2 HP) SUPPLY: 120 V, 1 PH, 60 HZ RATING: EXPLOSION PROOF
---	---	---	--	--	--	---	---

DRAWING APPROVAL		SIGN	DATE
	ENGINEERING MANAGER		
	PRODUCTION MANAGER		
	QC (DRAWING CONFORMANCE)		

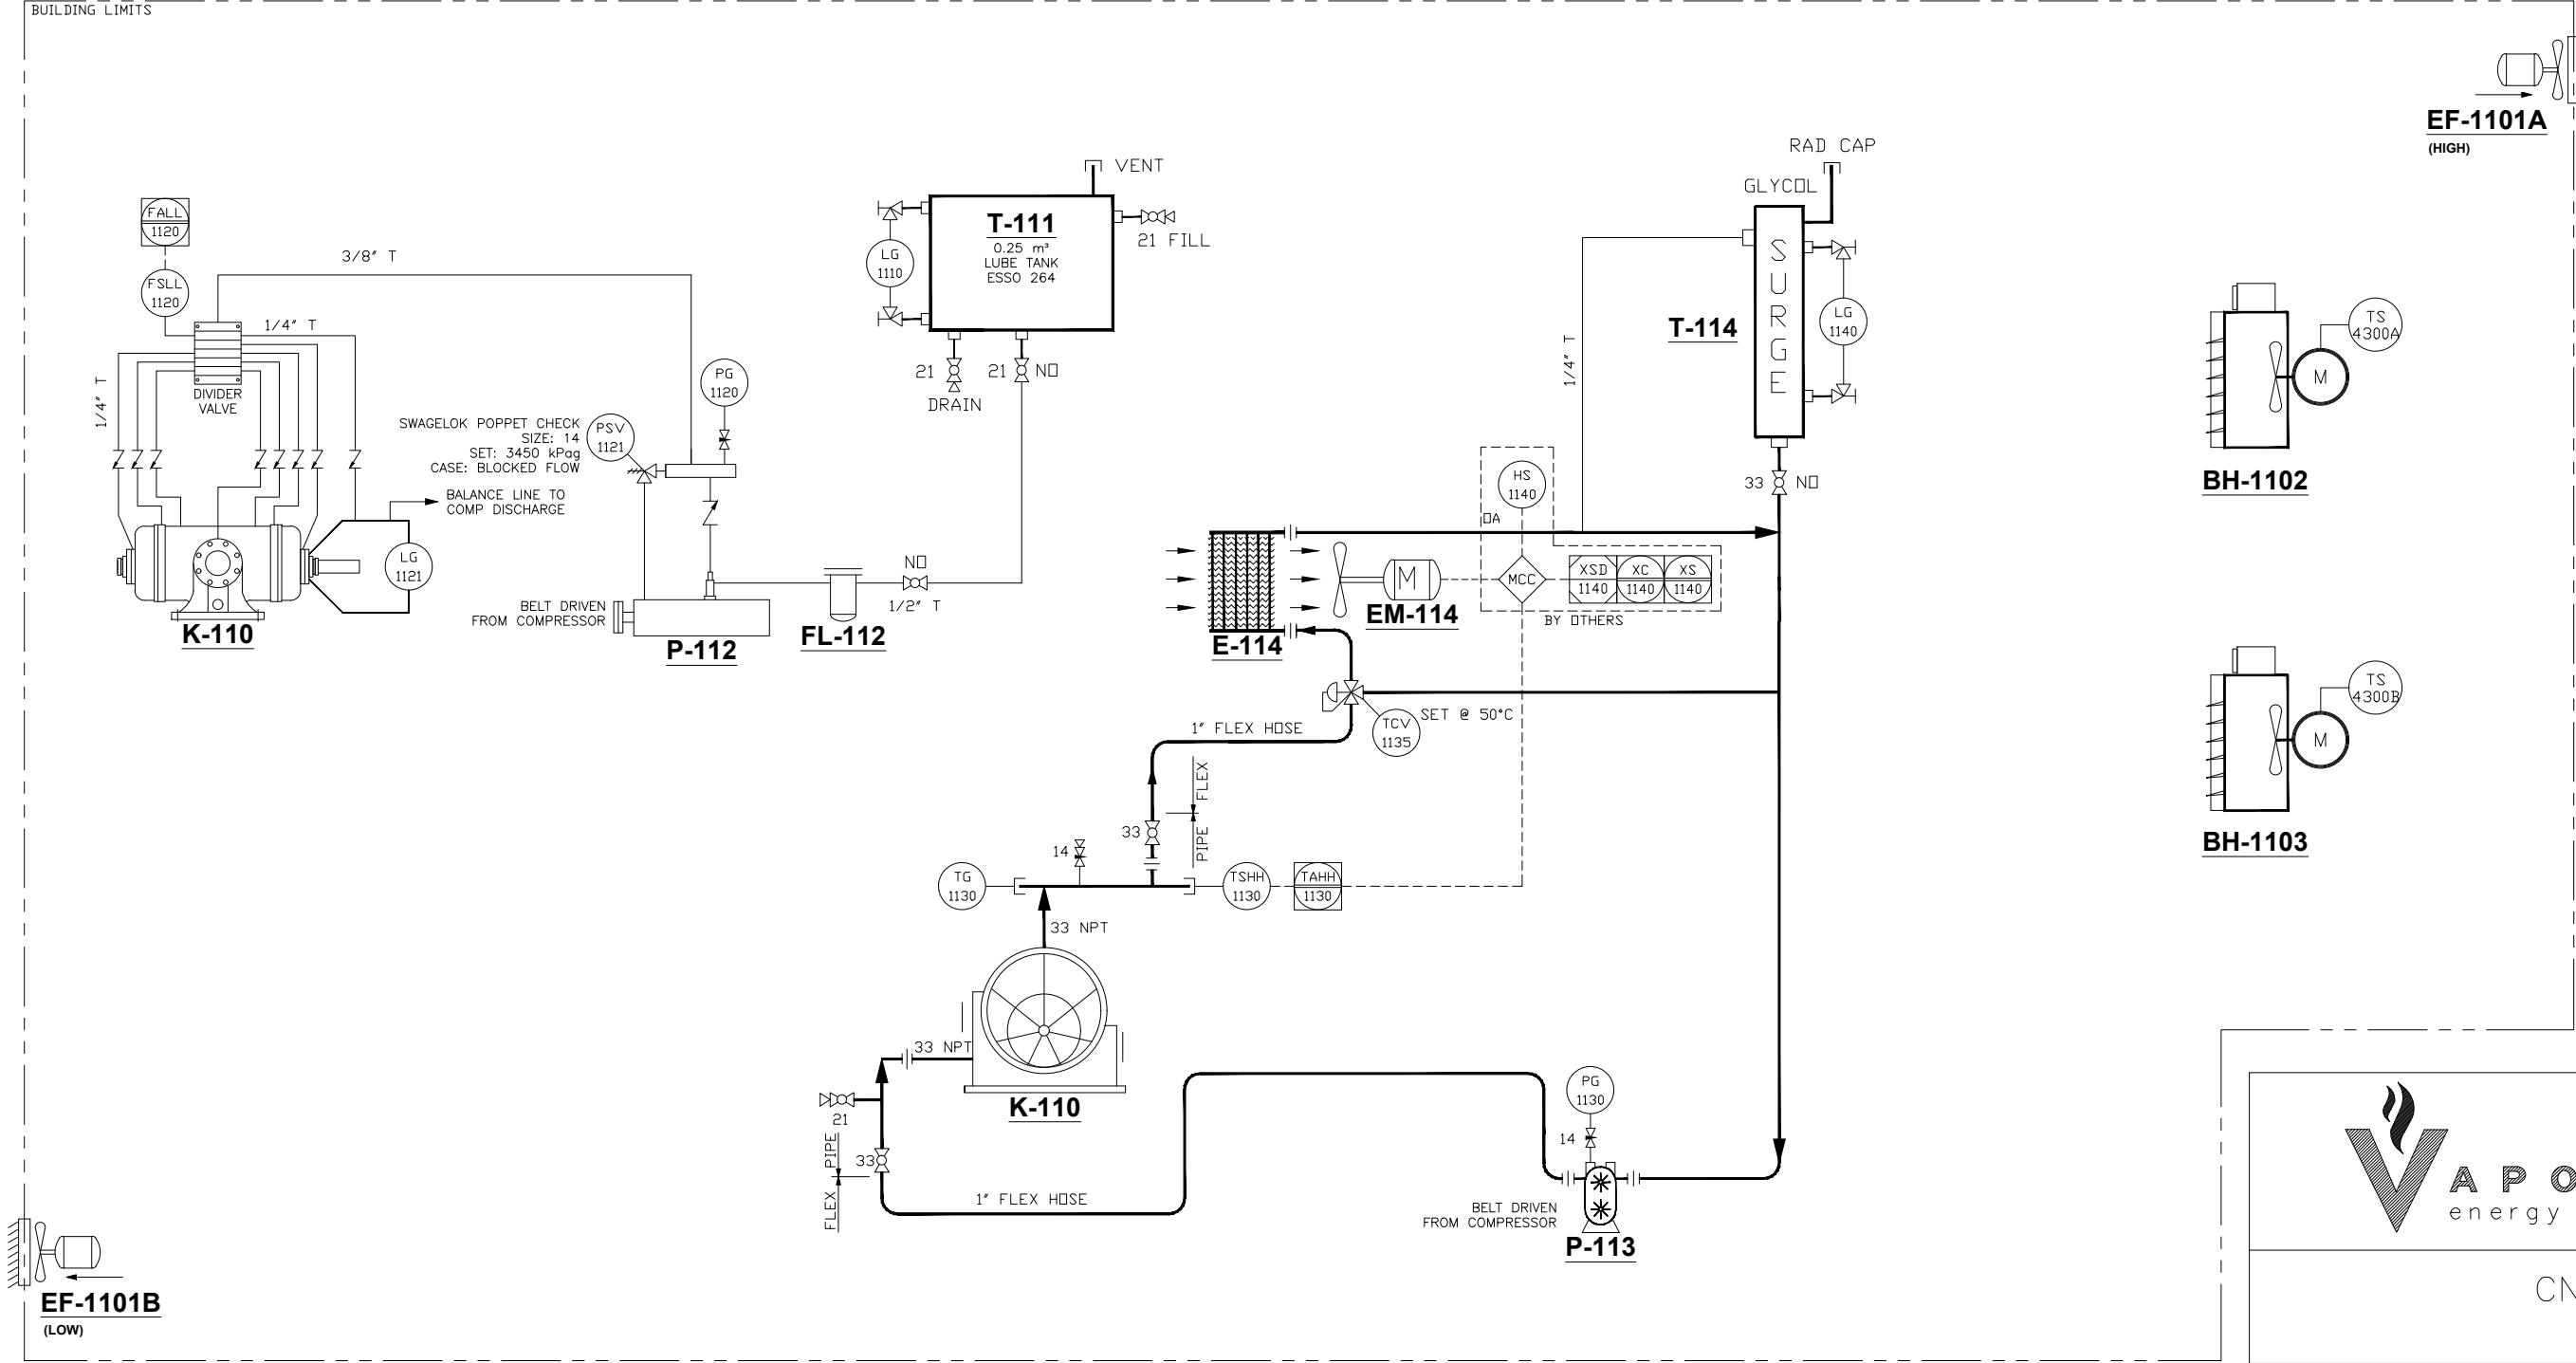

JAB

PERMIT TO PRACTICE
Heli Consulting Corp.

PERMIT NUMBER:
P13933
The Association of Professional
Engineers and Geoscientists of Alberta

83392 21-JUN-23



CNRL

SMITH OIL GAS CONSERVATION
VAPOUR RECOVERY UNIT

P&ID - AUXILIARIES

DRAWN BY	MM/DD/YY	DRAWING NO.	REV
EB	05/23/23	6556-101A/B	1
CLIENT DOCUMENT NO:			

GENERAL NOTES	NOZZLE DATA						REVISIONS					
	REF	FUNCTION	SIZE & RATING	PROJ.	PRESS (KPAg)	TEMP (°C)	REF	FUNCTION	SIZE & RATING	PROJ.	PRESS (KPAg)	TEMP (°C)
THIS DRAWING AND ANY DESIGNS SHOWN ARE THE CONFIDENTIAL PROPERTY OF VAPORTECH ENERGY SERVICES INC. AND MUST NOT BE USED, COPIED OR COMMUNICATED IN ANY FORM WITHOUT THE EXPRESS WRITTEN CONSENT OF VAPORTECH. 2018 VAPORTECH ENERGY SERVICES.												
							1	ISSUED FOR CONSTRUCTION			05/23/23	EB JC
							REV	DESCRIPTION			MM/DD/YY	BY CHK'D