

BH-XXX
BUILDING HEATER
DUTY:


KO-101
LP FLARE STACK
YEAR BUILT: 2014
SERIAL: 10008
S/S: 6098mm
MWP: 103 kPa

FL-101
LP FLARE STACK
SIZE: 6" (152.4mm) x 40' (12192mm)

KO-102
HP FLARE STACK
SIZE: 18"

FL-102
HP FLARE STACK
SIZE: 12" (304.8mm) x 60' (18288mm) TALL

FL-102
HP FLARE STACK
SIZE: 12" (304.8mm) x 60' (18288mm) TALL

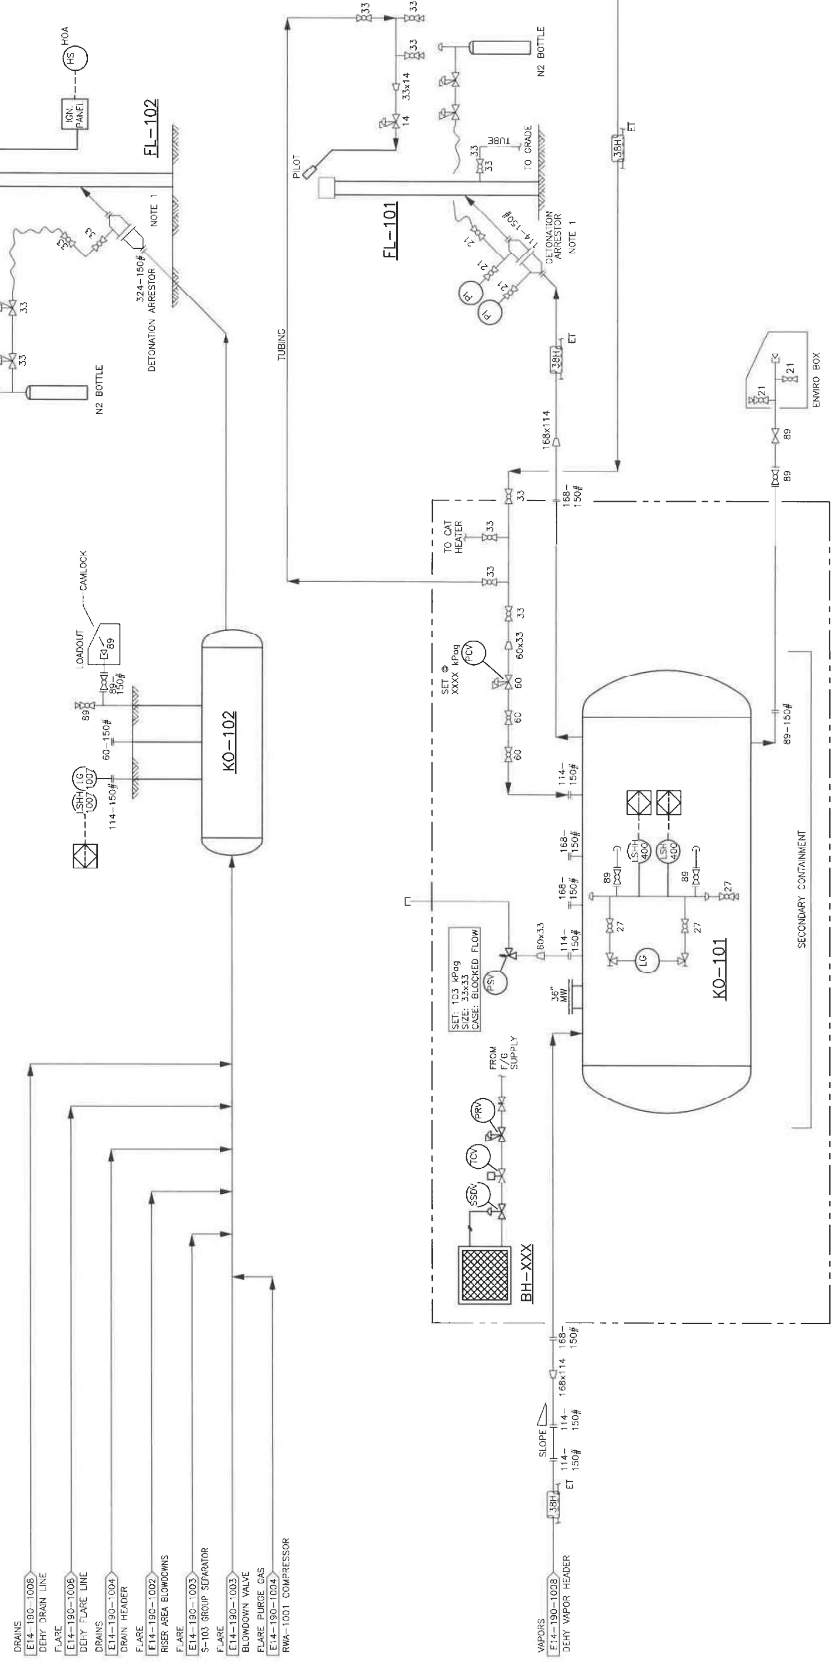

REV	DATE	BY	DESCRIPTION	CHK'D	APP'D	CLIENT	ENGINEERING & PERMIT STAMPS	DRAWN:	CHECKED:	DATE	BY
0	14.05.13	JB	AS-BUILT (ATEC E14-190)							14.05.13	JB
1	17.03.21	VE	AS-BUILT (MLE J09M 17640-01)								
2	17.08.17	VE	IFC								
3	17.11.14	GZ	AS-BUILT								

NOTES	1. ENSURE DETONATION ARRESTORS ARE REGULARLY CLEANED AND MAINTAINED TO PROVIDE RELIABLE RELIEF PATH.
-------	--

PROGRESS ENERGY	MILLENIA ENGINEERING
ELM WORTH	LSD 06-03-069-016 WGM
FLARE SYSTEMS	FLARE SYSTEMS
PIPING AND INSTRUMENTATION DIAGRAM	PIPING AND INSTRUMENTATION DIAGRAM
SCALE: 1/8" = 1'-0"	DRAWING NAME: E14-190-101.3
M.E. JOB#:	17841-01
DATE:	14.05.13
REV:	3