



FS-560
LP FLARE STACK
89x2400mm HSK

FS-550
HP FLARE STACK
2134x4275mm HSK
3/2" OUTLET
1000MM DIA. MANWAY

 
S-550
HP FLARE KNOCK OUT DRUM
2134mm Ø x 4275mm S/2
D.P. 350 C.A. 3/2" TO 3FC
1000MM DIA. MANWAY
OVERSIZES @ 95 BPD MAX



COMPRESSOR #1
REF. D-MFS-97134-1013


LINE HEATER PACKAGE
REF. D-MFS-97134-1009

HEAT MEDIUM PACKAGE
REF. D-MFS-97134-1018



DEHYDRATOR BUILDING #1
REF. D-MFS-97134-1015

FUTURE DEHYDRATOR BUILDING #2

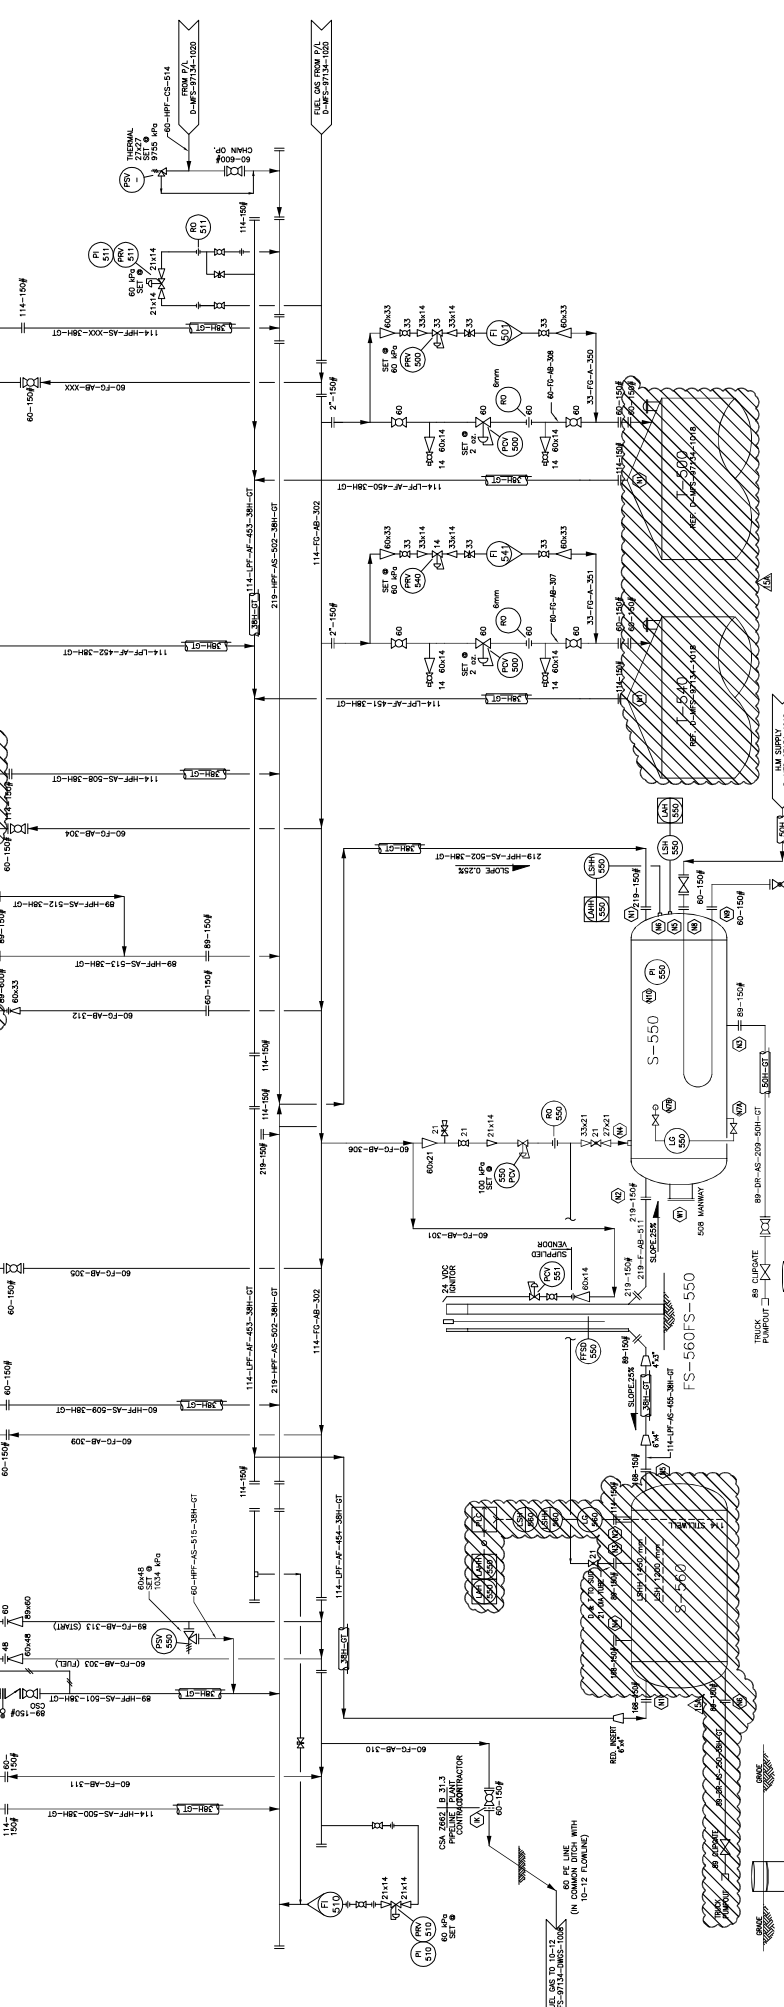

DWG. NO.	REFERENCE DRAWINGS	REV	REVISIONS	DATE	BY	CHK'D	APP'D	OWNER
056734	11	ADD COMPRESSOR #1, AS-BUILT	99-09-13	NH				
056734	10	ADD COMPRESSOR #1, ISSUED FOR CONSTRUCTION	99-07-13	CK	BPH			
056734	14	ISSUED FOR OGC PERMIT	2007-05-01	VC	AD	AD		
056734	13	AS-BUILT FROM FIELD PHOTOS (CLOUDED AREAS ONLY)	05-09-15	NR				
056734	12	ISSUED FOR APPROVAL & TITLE BLOCK CHANGED	05-06-01	NN	JLM			

ENGINEER AND PERMIT STAMPS	
DESIGNED	DOWN
CHECKED	97-08-23
PROCESS OK	
MECH. OK	
STRUCT. OK	
ELECT. OK	
OWNER APP.	
OWNER APP.	

Canadian Natural

RED CREEK
GAS DEVELOPMENT
P & ID FLARE / FUEL
LSD: 15-01-86-22 WGM

DWG. NO. 056734
SCALE: NONE
D-MFS-97134-1019