


V-XXXX
 FIREWATER KNOCK-OUT
 SIZE: 1000 GAL. 30" DIA. 5/8"
 ONLY: JAB01.1
 DATE: 01/17/2018
 BY: 18772
 OUT OF SERVICE

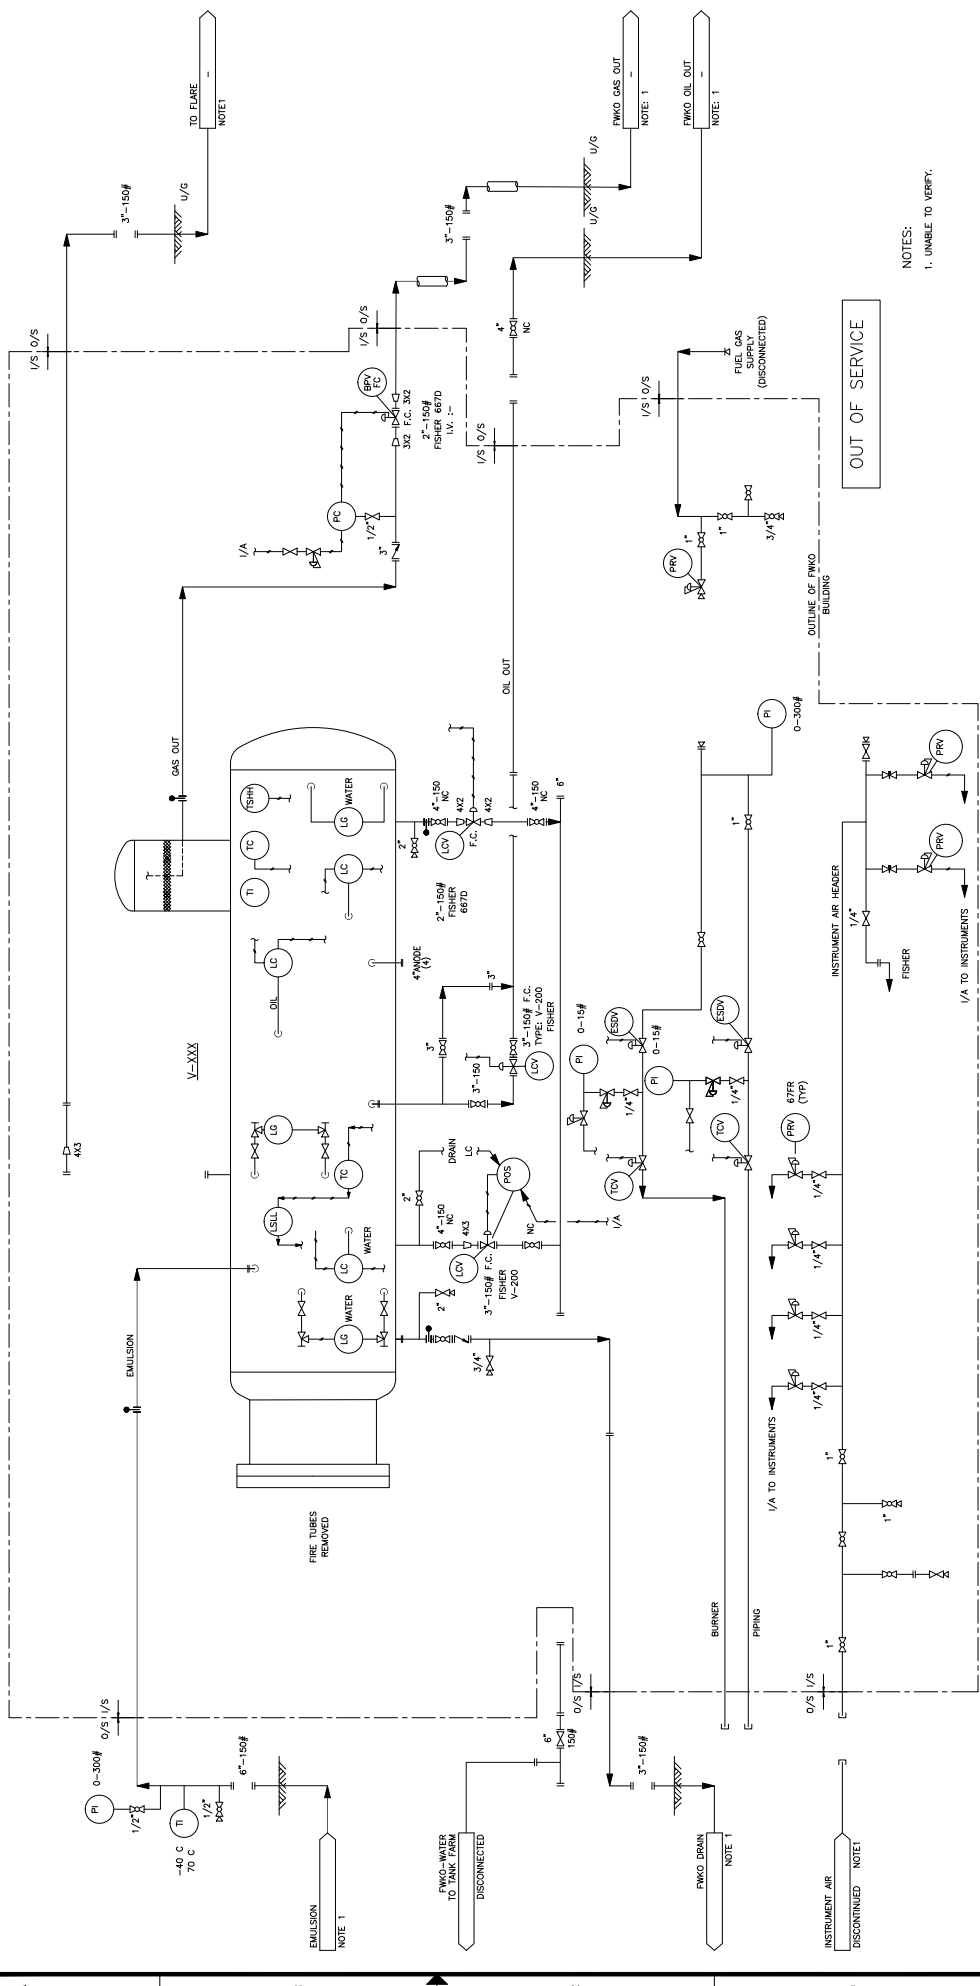

NOTES:
 1. UNABLE TO VERIFY.

AS-BUILT WHO AUTHENTICATION
 This drawing is solely prepared for AS-BUILT ITEMS RECORDED IN PLACE. No assumption of liability is taken by the engineer or contractor for any errors or omissions. It shall be the responsibility of the client to verify the accuracy of the information and to ensure that the construction or modification to the site or drawing.



STURGEON LAKE CENTRAL BATTERY
 FREE WATER KNOCK OUT
 PIPING AND INSTRUMENTATION DIAGRAM

REV.	DESCRIPTION	BY	DATE	CHK	APP.	CLIENT	DATE	SCALE	DRAWING NO.	REV.
0	AS-BUILT (REQLINE 02279)	RB	2018-04-04					N.T.S.	SSN1029-220-0014	0

DATE	DESIGNED BY:	CHECKED BY:	APPROVED BY:	CLIENT BY:
2018-04-04				