


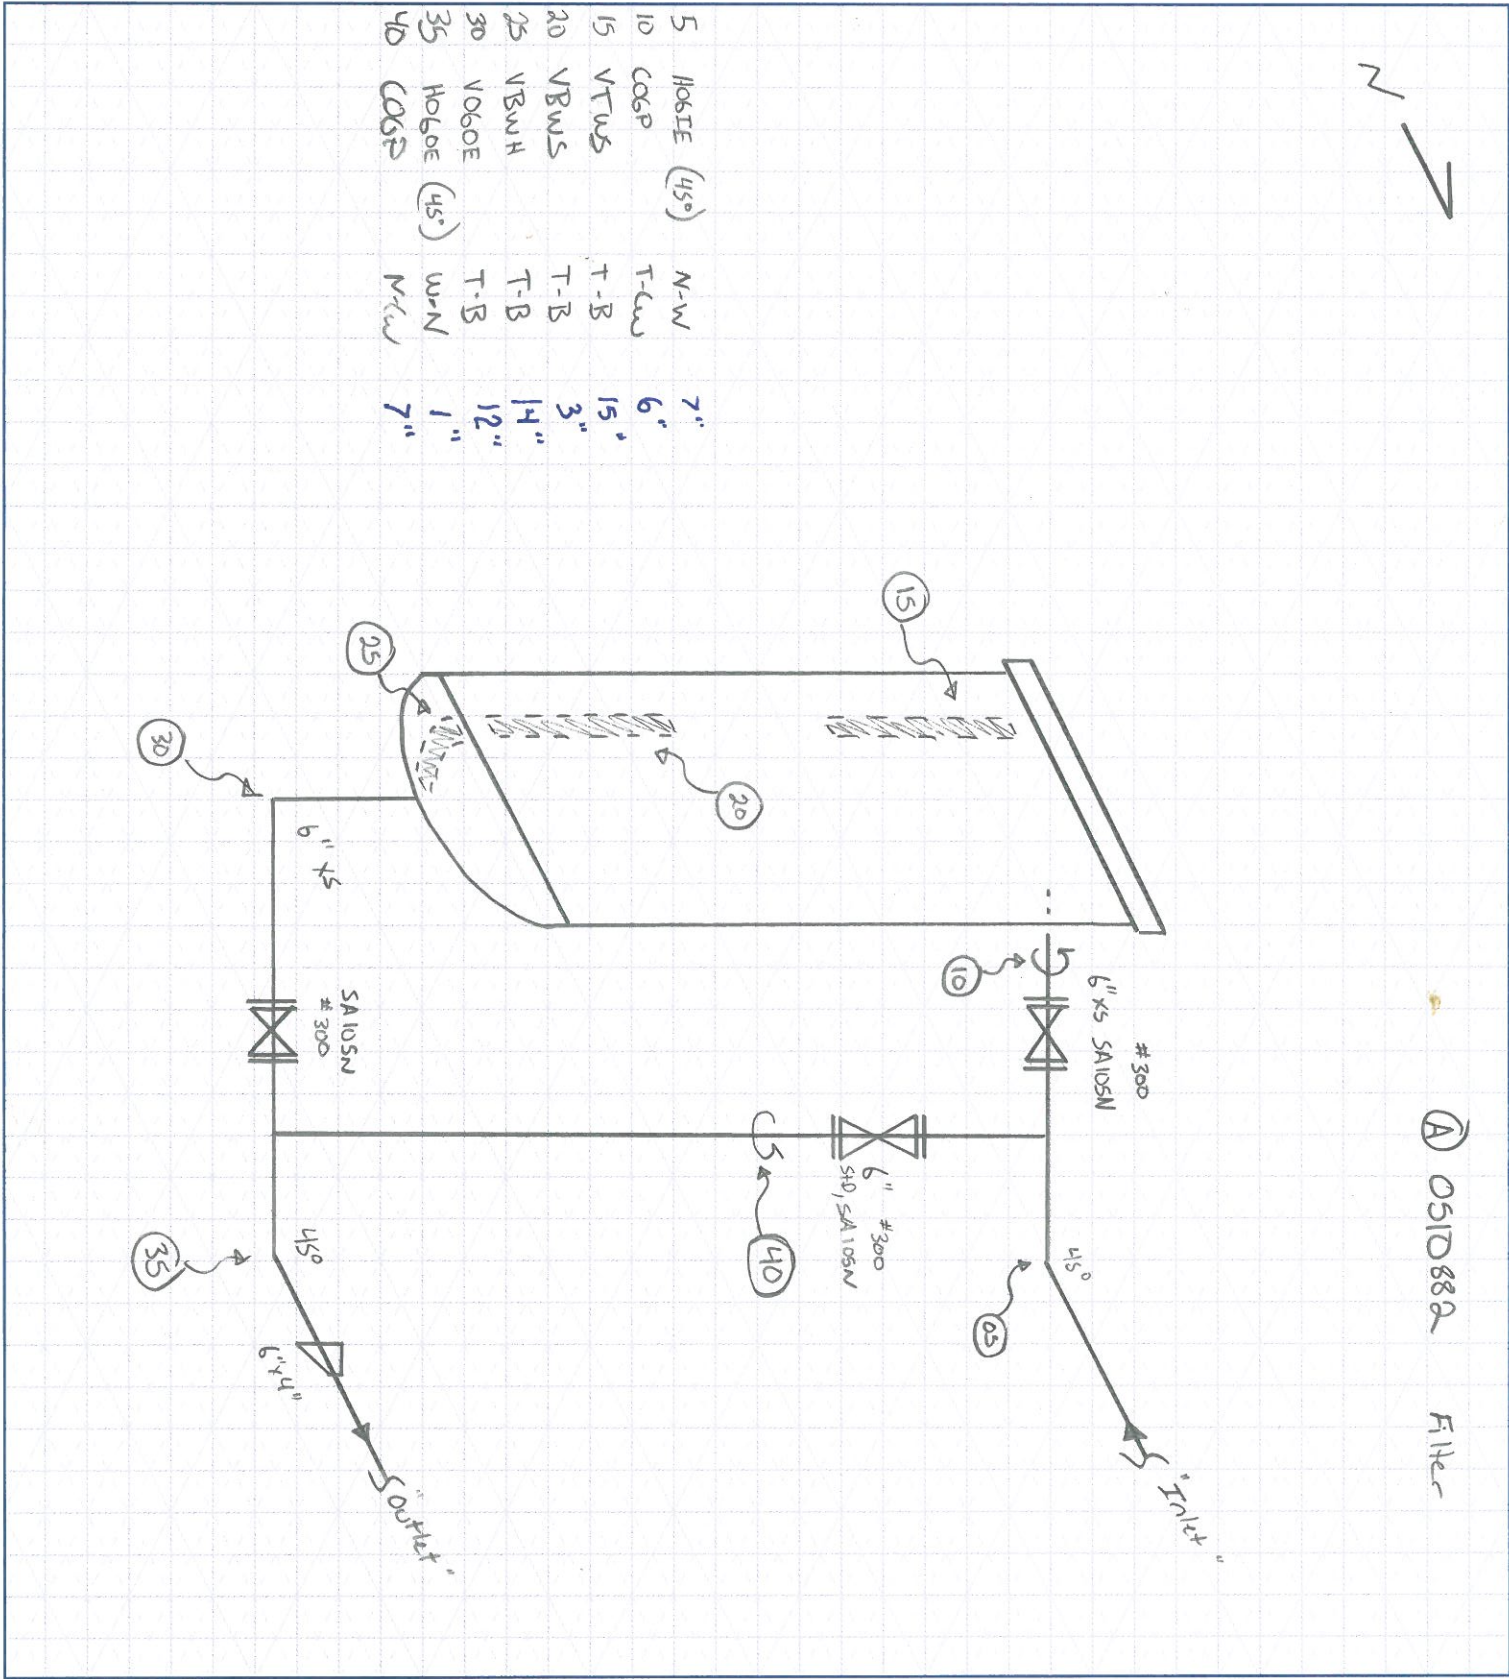

CUSTOMER: CNAL FACILITY: Brintnell N. Pad #24 LSD: 06-26-082-20W4M
P & ID: / DRAWN BY: MD DATE: 07/14/2010 DRAWING NO. DB-008

VESSEL INFORMATION:

Equip. No. / Pro.Reg.No (A) 0510882 C.R.N. R5736.2 Serial No 3497-1 Yr. Inst. /
Code/Div. W Size: 34" O.D. 40" H Manufacturer: Moss Fabrication LTD Yr. Blt. 2004
C. Stamp Yes Service: Sweet PWHT: / J.E.: / Radiography: 2 Insulated: NO

HEAD:

Top Mat'l / Top Nom / Top C.A. / SHELL: Material / Nominal / C.A. /
Btm Mat'l / Btm Nom. / Btm C.A. /

BOOT:

Head Mat'l / Head Nom / Head C.A. / CHANNEL: Top Mat'l / Top Nom. / Top C.A. /
Shell Mat'l / Shell Nom. / Shell C.A. / Btm Mat'l / Btm Nom. / Btm C.A. /

MAWP Shell side: 720 PSI @ Temp. 130°F MAWP Tube Side: / @ Temp. /

PIPING INFORMATION:

Circuit. No. / Line No. (s) (PLEASE PUT LINE NUMBERS ON APPLICABLE LINES ON THE DRAWING)
Piping Class / Service: / Yr. Blt. /
MAWP: / @ Temp. -20°F Size & Schedule of Piping (PLEASE PUT APPROPRIATE SIZES AND SCHEDULES OF PIPING ON DRAWING)

A0510882 UT Readings
Readings in Inches

	PNT 1	PNT 2	PNT 3
LOC 5	0.257	0.296	0.285
LOC 10	0.442	0.461	0.447
LOC 15	0.772	0.779	0.776
LOC 20	0.767	0.774	0.772
LOC 25	0.745	0.805	0.757
LOC 30	0.409	0.476	0.418
LOC 35	0.268	0.305	0.280
LOC 40	0.281	0.304	0.290