

THIS DRAWING IS THE EXCLUSIVE PROPERTY OF PRESSON ENERGIFLEX AND MAY NOT BE COPIED OR COMMUNICATED TO A THIRD PARTY WITHOUT THE WRITTEN AUTHORIZATION OF PRESSON ENERGIFLEX

BF-4000A/B

P-4001/4002

V-400C

P-400C

F-4001 A/B/C

UH-4002

EXHAUST FANS
ENERTECH ET12
c/w 1/4 HP 120/240/1PH/60HZ K.P. MOTOR
6 ACPH (FROM EMISSION STUDY)





 
 
 

CHEMICAL INJECTION PUMP
 TEXTTEAM 4334-2P 2 HEADED INJECTION PUMP,
 5000 PSI MAX DISCHARGE PRESSURE, 20 GPD CAPACITY
 c/w 1 1/2 HP 480/3/60HZ TEMP MOTOR

FUEL GAS SCRUBBER
OD x 5'-0" S/S x 250 PSIG
-20/130°F, 1/8" C.A.

METHANOL INJECTION PUMP
TEXTSTREAM 4334-4P 4 HEADED INJECTION PUMP
5000 PSI MAX. DISCHARGE PRESSURE, 40 GPD CAPACIT
c/w 1/2 HP 480/3/80 HZ TEXT MOTOR

CHEMICAL FILTER
1" NPT FILTER BASE #FB1307

BUILDING HEATER
RUFFNECK AH-20A0A51-A1-2A
GLYCOL HEATER EXCHANGER UNIT HEATER c/w
X.P. 120/1PH/60HZ ELECTRIC MOTOR
c/w DEFENDER XT-311 THERMOSTAT

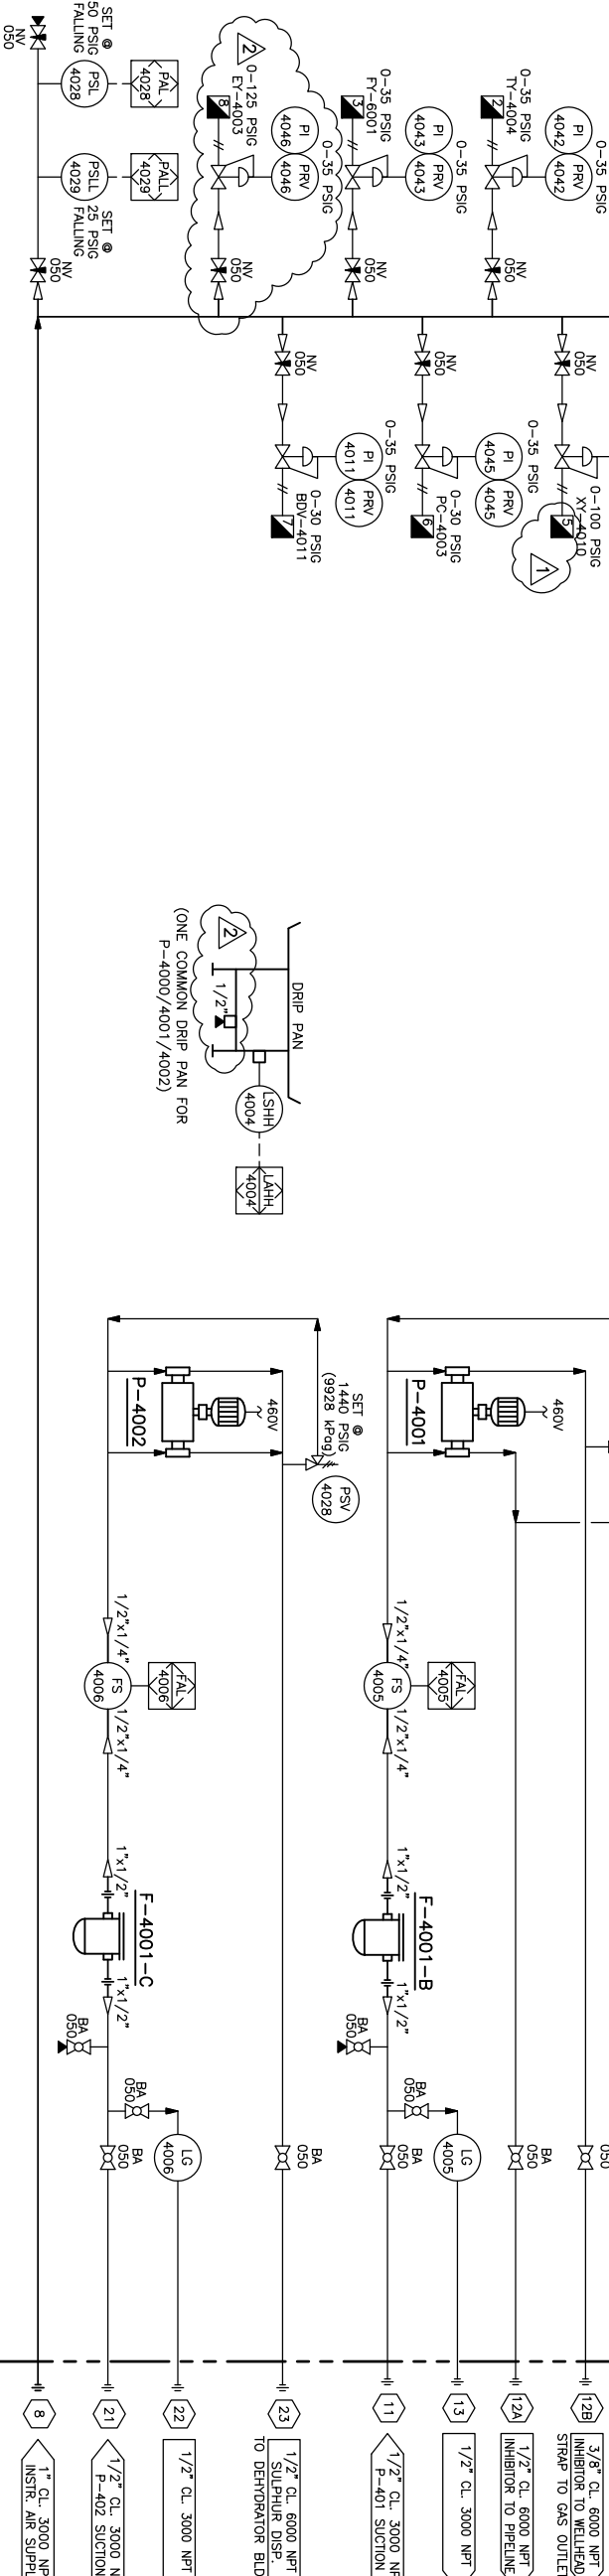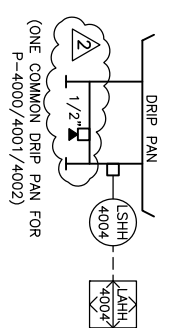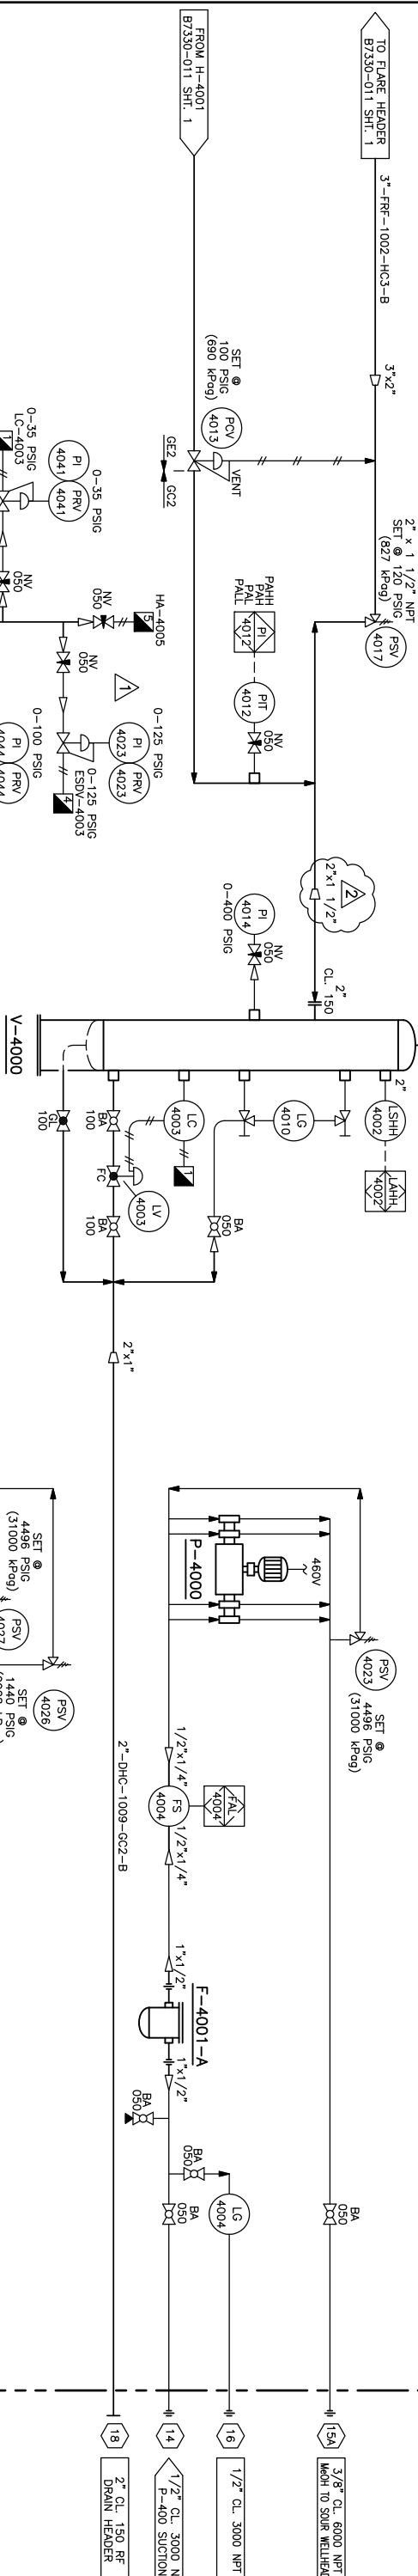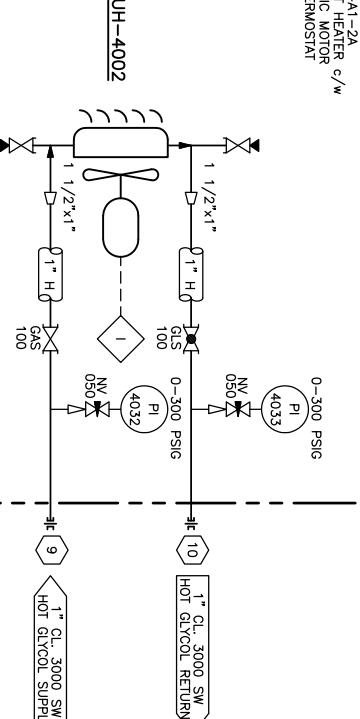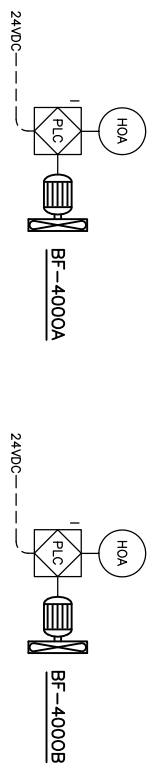

NOTES:

- 1) COLD FILL LINE TO BE MARKED ON LINE HEATER
- 2) ALL TUBING TO BE 316 SS c/w 3/16 SS SWAGelok TUBE FITTINGS.
- 3) ALL VENTING INSTRUMENTS TO BE VENTED ON A COMMON VENT HEADER AT SAME HEIGHT.
- 4) NO SOCKET WELD OR THREADED FLANGES IN SOUR SERVICE.
- 5) ELECTRICAL NOT IN PRESSION SCOPE OF WORK.



2	AS BUILT	RAW	07/04/04
1	ADD PRV-4023 AND PI-4023	TBB	07/02/27
0	ISSUED FOR CONSTRUCTION	EB	06/11/23
B	RE-ISSUED FOR APPROVAL	AEB	06/10/18
A	ISSUED FOR APPROVAL	SM	06/08/25
0.	REVISION	BY	DATE
		CHGO.	

CUSTOMER BP CANADA ENERGY COMPANY		JOB NO. B7330-01
119-22-00		
PRESSON ENERFLEX		
PRODUCT: TWO LAKES, 3-3 LSD: 03-03-63-13 W6M		
TITLE: SOUR LINE HEATER SKID PACKAGE P & ID		
DRAWN AEB	CHECKED NTS	SCALE NTS
DATE 06/08/08		DRAWING NUMBER B7330-011
		SHT. 2 OF 3
		/