



PRINTED: Monday, January 20, 2014 9:17:31 AM DWG NAME: H:\PROJECTS New MUS\Design Drafting\General\PRR\PRR-52-PR-PI-0004 Rev 0A.dwg
 UPDATED: Friday, November 15, 2013 3:44:48 PM BY: Manual

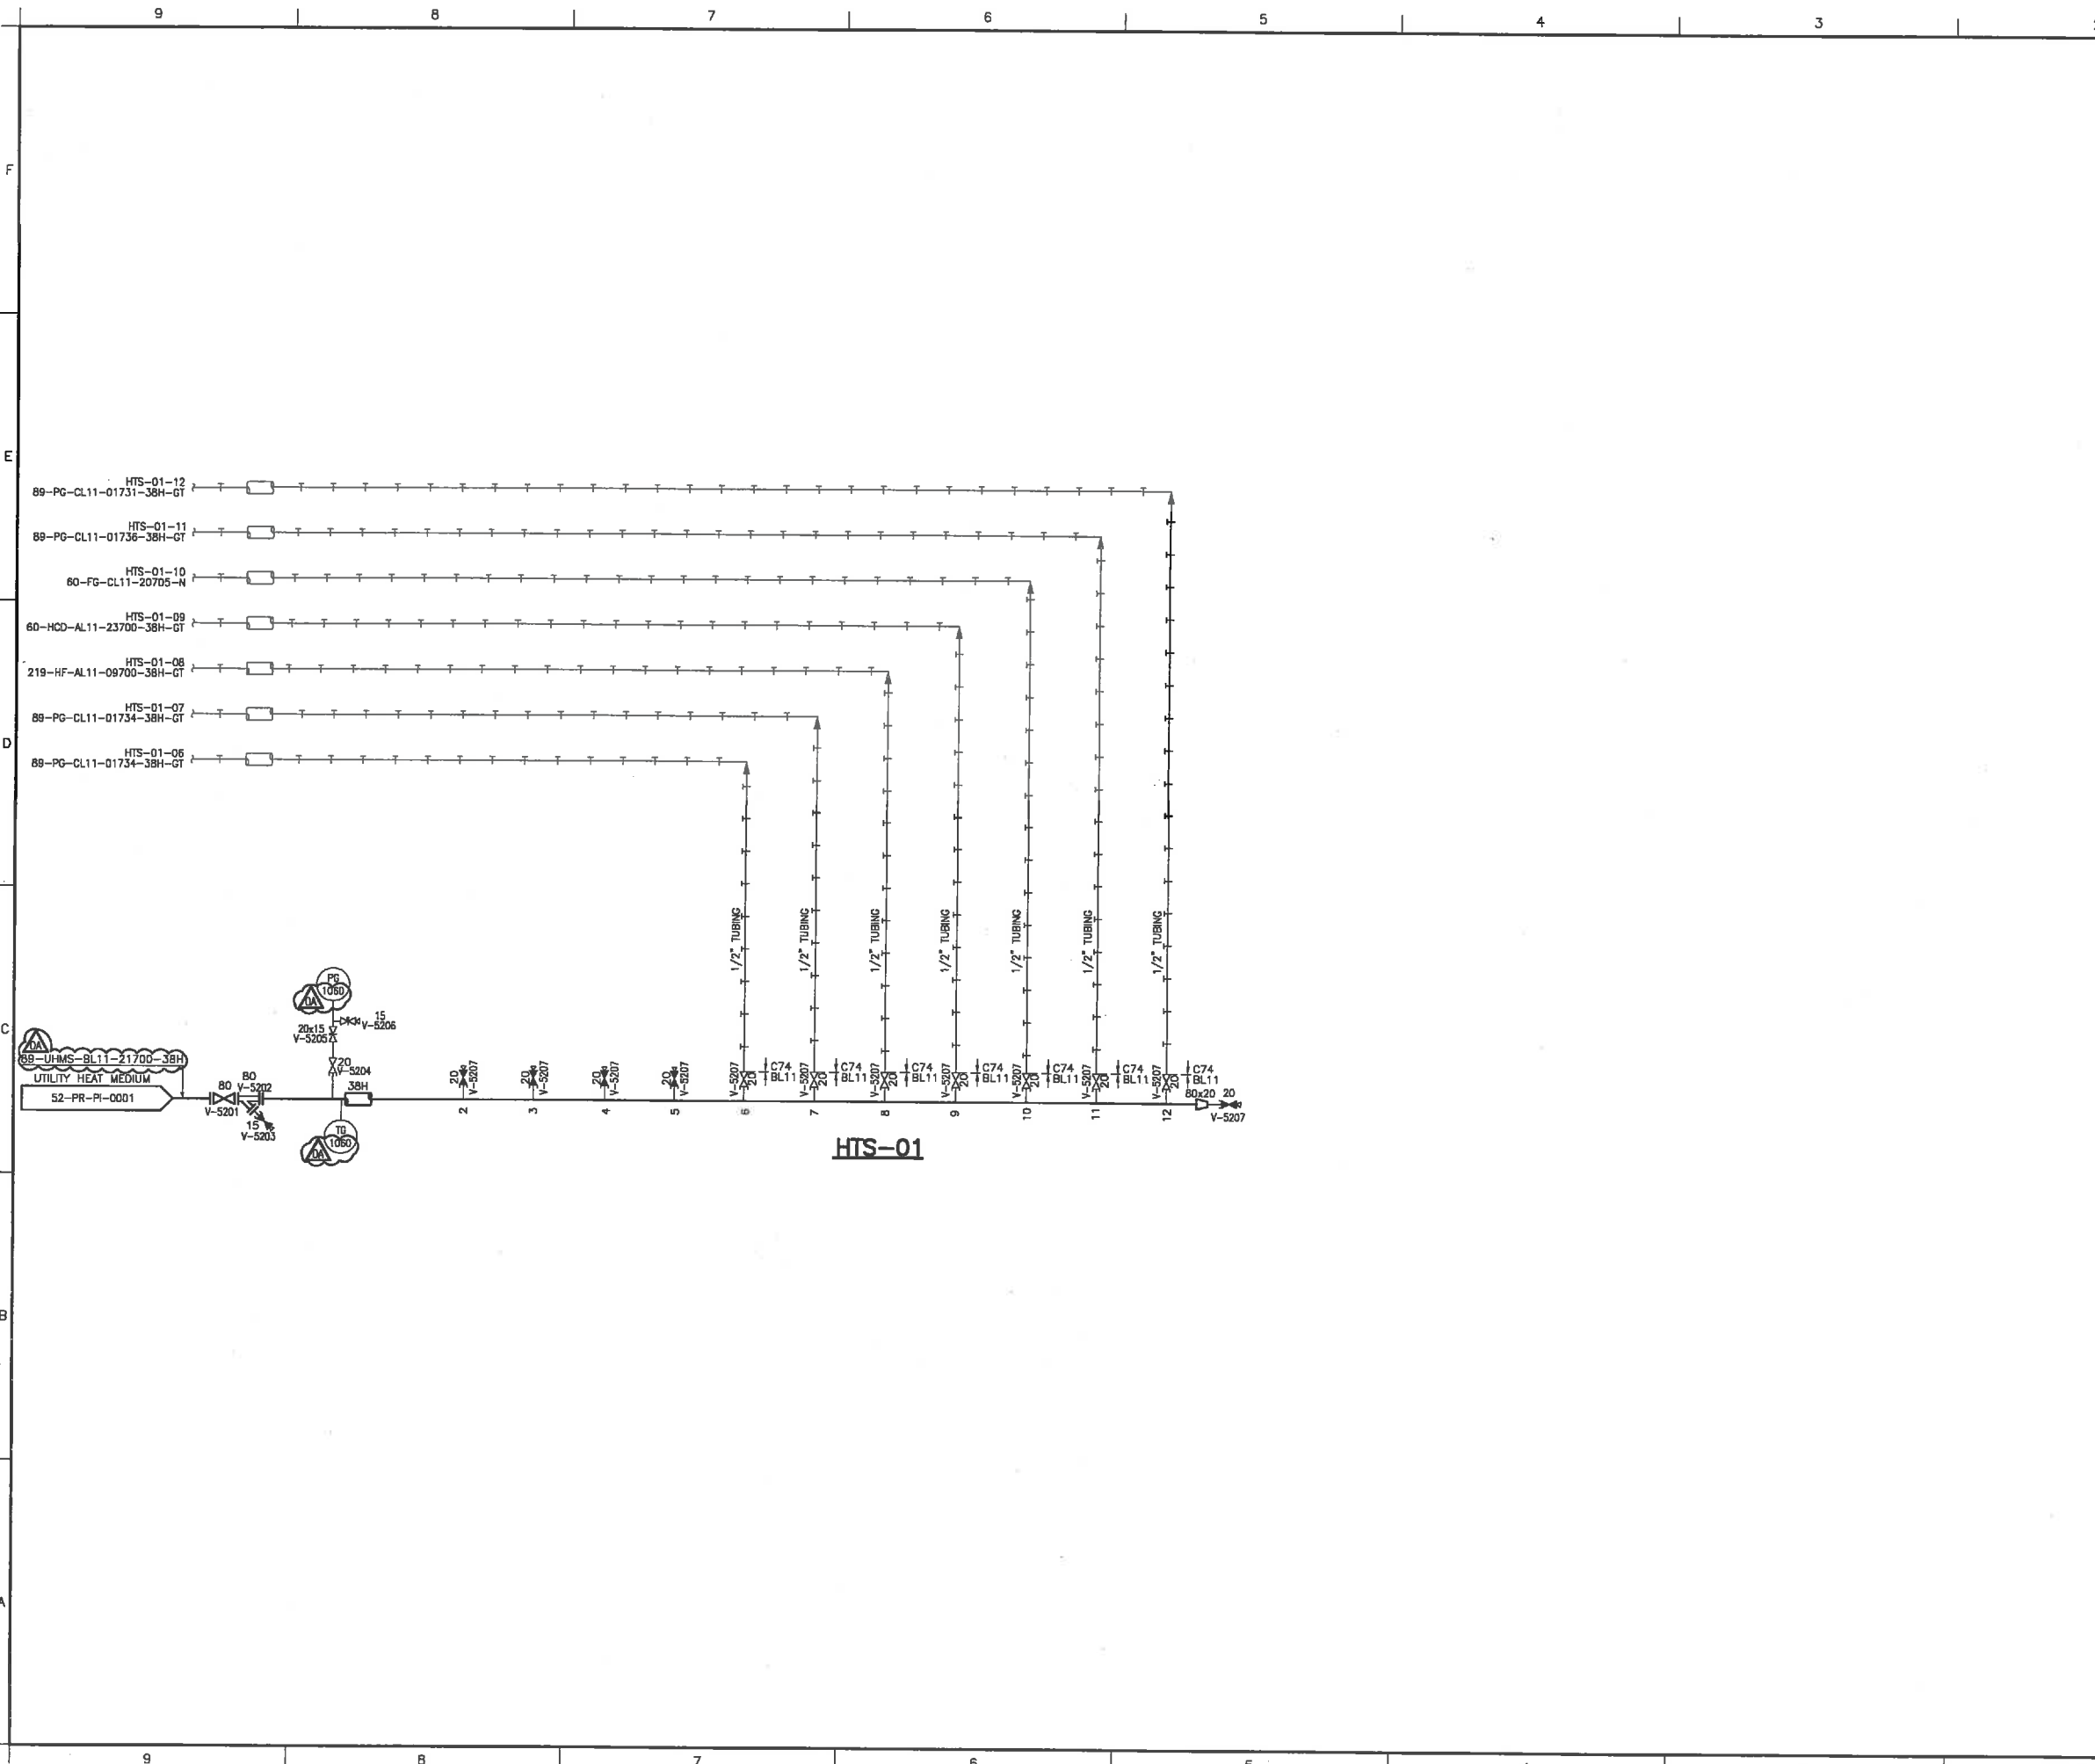

GENERAL NOTES:
 1. PREINSULATED TUBING TO BE USED FOR ALL TRACER CIRCUITS.

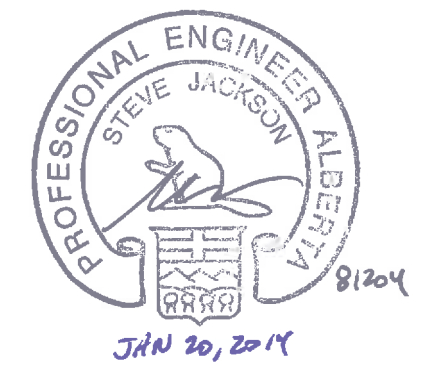

0A	REVISED AS MARKED	NOV.12/13	MFF
0	RELEASED FOR FABRICATION	OCT.08/13	SSE
NO.	REVISION	DATE	BY
PROJECT NAME: FERRIER CENTRAL PROCESSING FACILITY			
CLIENT: DEVON CANADA c/o WORLEY PARSONS			
DOCUMENT NAME: HEAT TRACING SUPPLY MANIFOLD #1 PIPING AND INSTRUMENTATION DIAGRAM			
THERMO DESIGN ENGINEERING LTD. DESIGN • FABRICATION • INSTALLATION EDMONTON, ALBERTA, CANADA <small>APEDA PERMIT NUMBER: P2800</small>		P. CHG. STAMP: 	
<small>THIS DRAWING IS THE CONFIDENTIAL PROPERTY OF THE FIRM AND IS LOANED ON THE UNDERSTANDING THAT IT IS NOT TO BE COPIED OR REPRODUCED OR TO A THIRD PARTY WITHOUT THE WRITTEN APPROVAL OF TDE.</small>			
TDE JOB NUMBER:	12-118		
DOCUMENT NUMBER:	DFR-52-PR-PI-0004	SHEET:	REV: 0A