



PRINTED: Monday, January 20, 2014 9:17:38 AM DWG NAME: H:\PROJECTS New NDS\Design Drafting\General\DFR\VID\DFR-52-PR-PI-007 Rev 0A.dwg
 UPDATED: Thursday, November 28, 2013 9:28:59 AM BY: Len

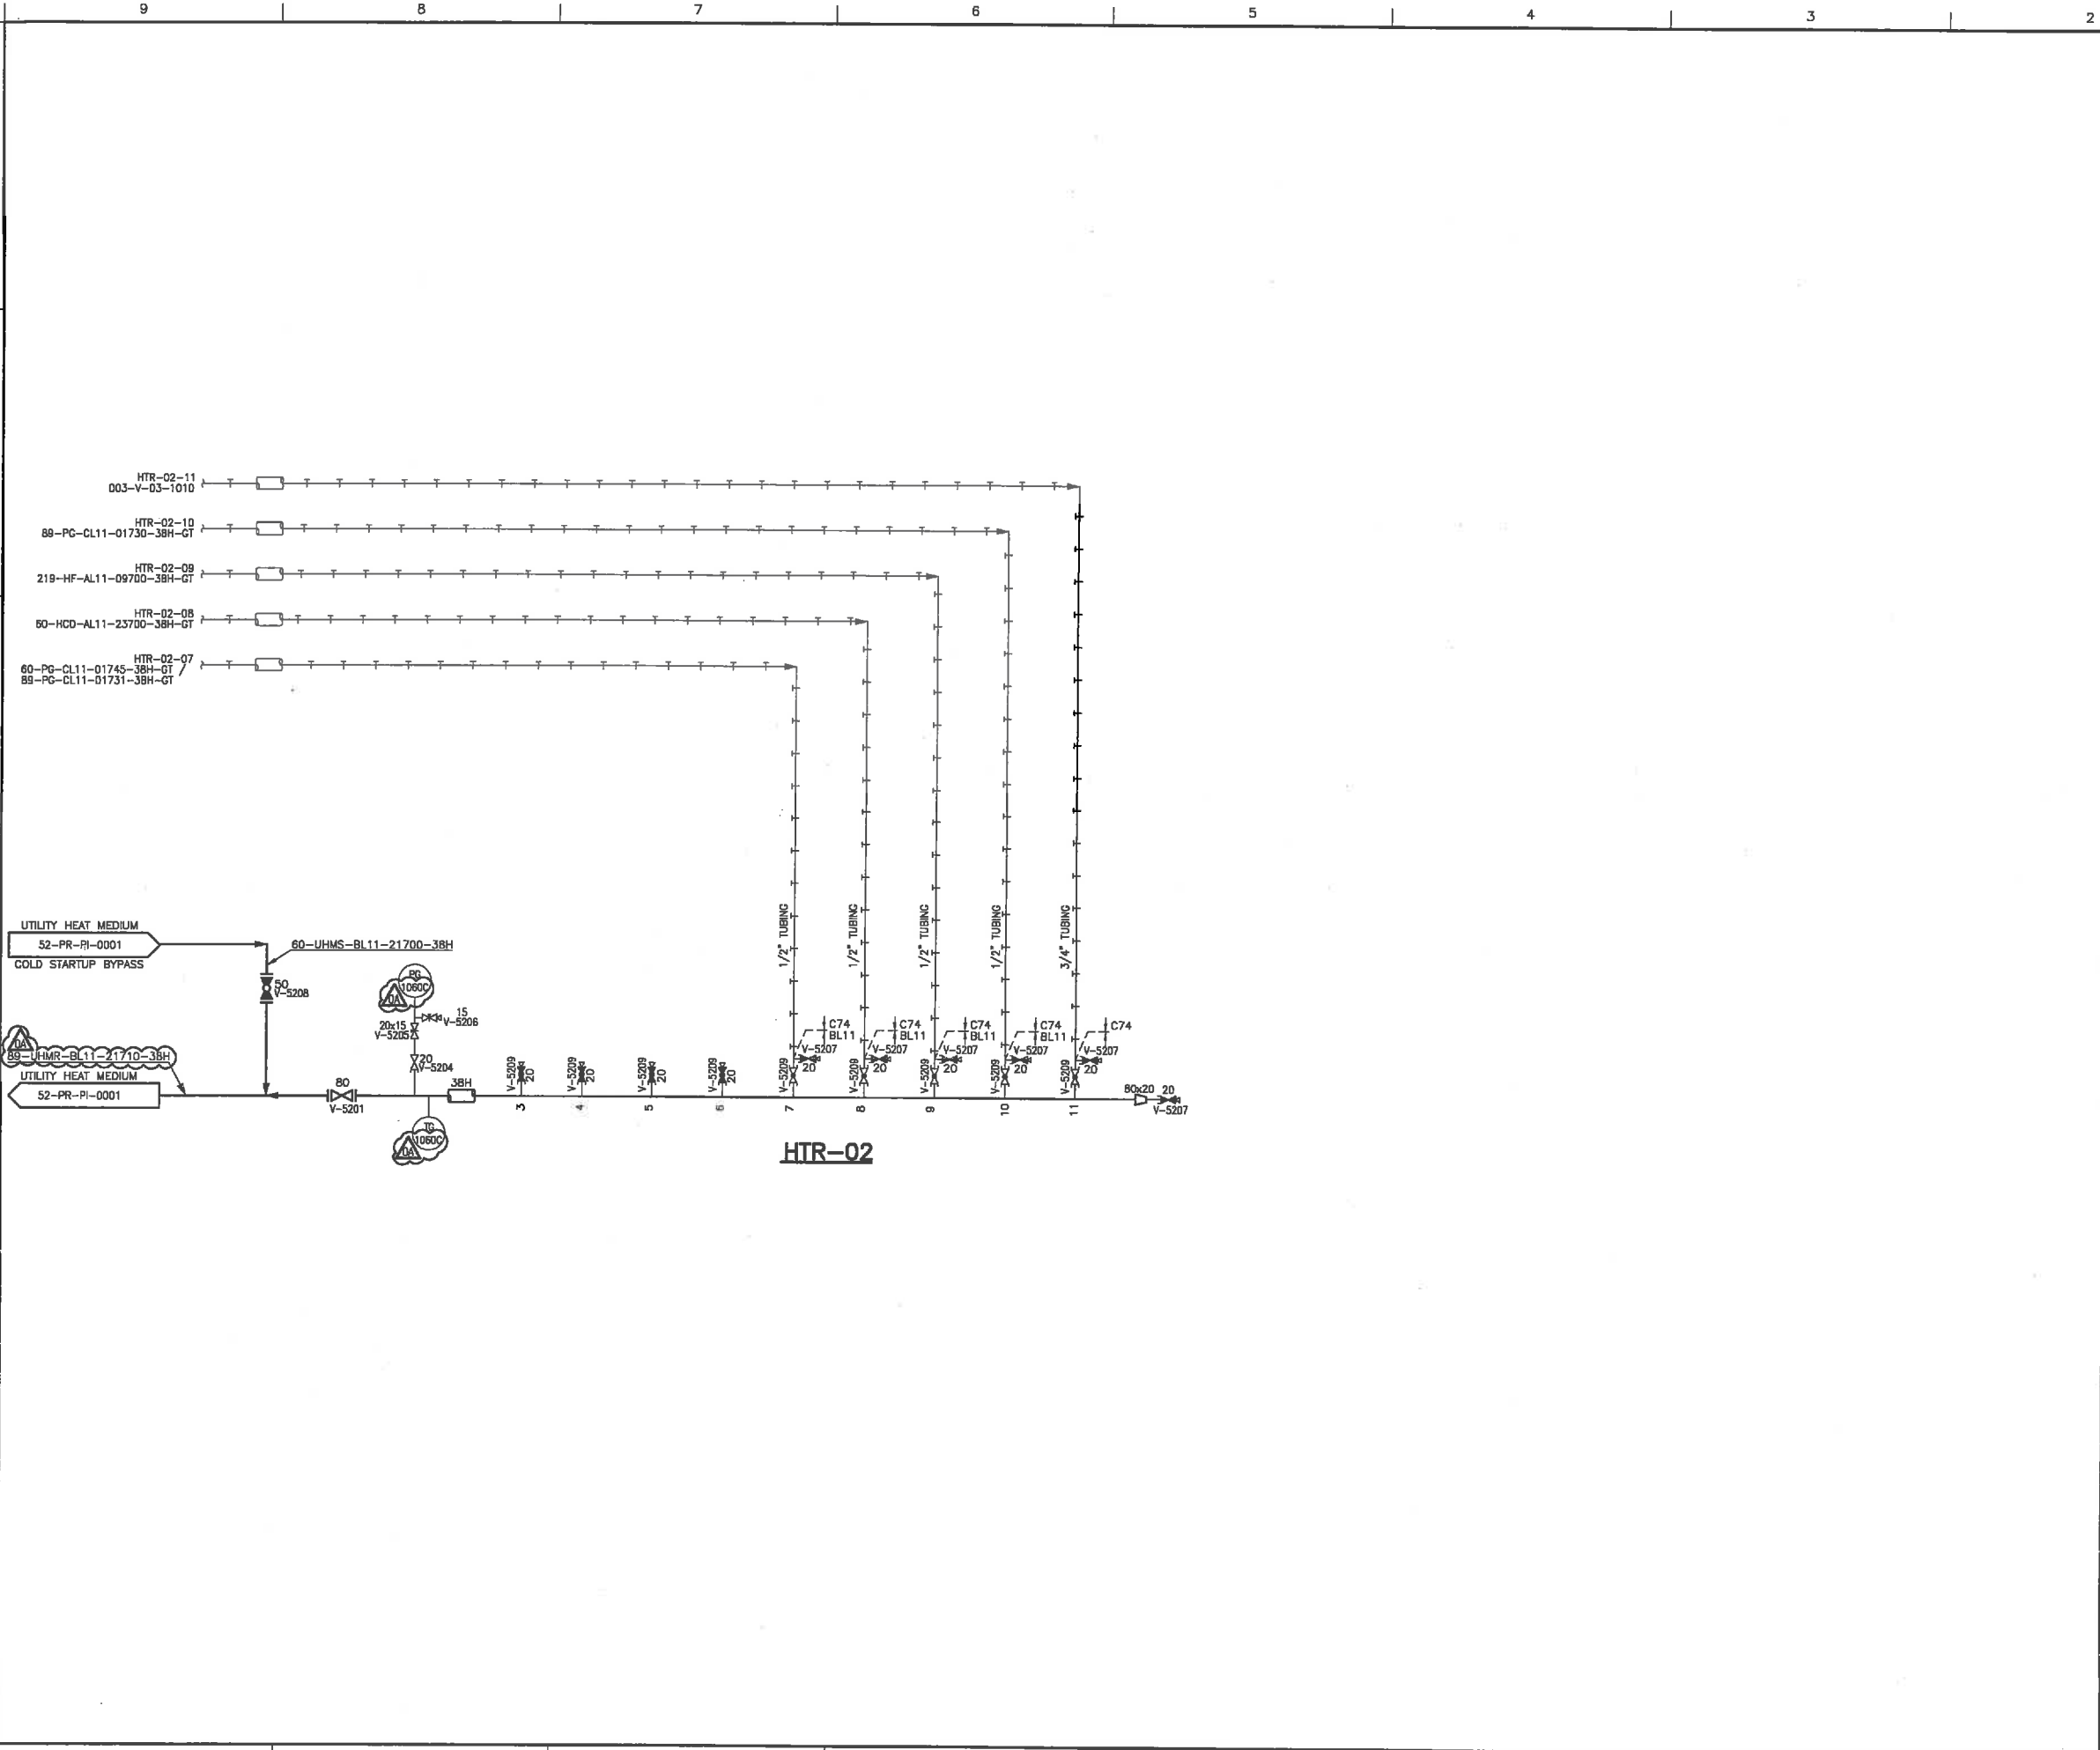

GENERAL NOTES:
 1. PREINSULATED TUBING TO BE USED FOR ALL TRACER CIRCUITS.

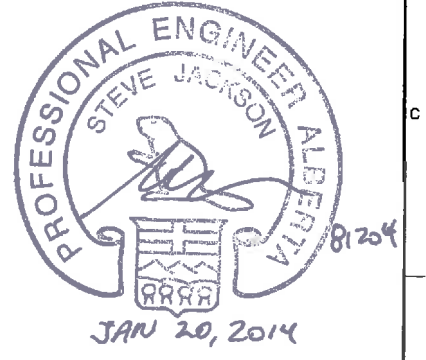

NO.	REVISION	DATE	BY
0A	REVISED AS MARKED	NOV.12/13	MFF
0	RELEASED FOR FABRICATION	OCT.08/13	SSE

PROJECT NAME				
FERRIER CENTRAL PROCESSING FACILITY				
CLIENT				
DEVON CANADA c/o WORLEY PARSONS				
DOCUMENT NAME				
HEAT TRACING RETURN MANIFOLD #2 PIPING AND INSTRUMENTATION DIAGRAM				
				P. ENG. STAMP:
<small>THIS DRAWING IS THE CONFIDENTIAL PROPERTY OF THE AEP AND IS LOANED ON THE UNDERSTANDING THAT IT IS TO BE USED ONLY FOR THE PROJECT AND NOT TO BE REPRODUCED OR TRANSMITTED TO A THIRD PARTY WITHOUT THE WRITTEN AUTHORIZATION OF THE AEP.</small>				
TDC JOB NUMBER	12-118		DATE	NOV. 12/13
DOCUMENT NUMBER	DFR-52-PR-PI-0007		SHEET	0A