


V-801
AIR RECEIVER
762mm OD. x 2134mm S/S
D.P.: 1379 kPa @ 34.3°C

F-101
INSTRUMENT AIR FILTER
XEBEC TYPE 8HD06T51
115/1/60
DEWPOINT OF -40°C

M-810
INSTRUMENT AIR DRYER PACKAGE
XEBEC TYPE 8HD06T51
115/1/60
DEWPOINT OF -40°C

C-820A/B
INSTRUMENT AIR COMPRESSOR
DURAVANE ROTARY VANE DV15AS
1.7 SM3/MIN @ 689 kPa
MOTOR 15 HP 460/3/60 TEFC

CM-820A/B
INSTRUMENT AIR COMPRESSOR MOTOR
15 HP

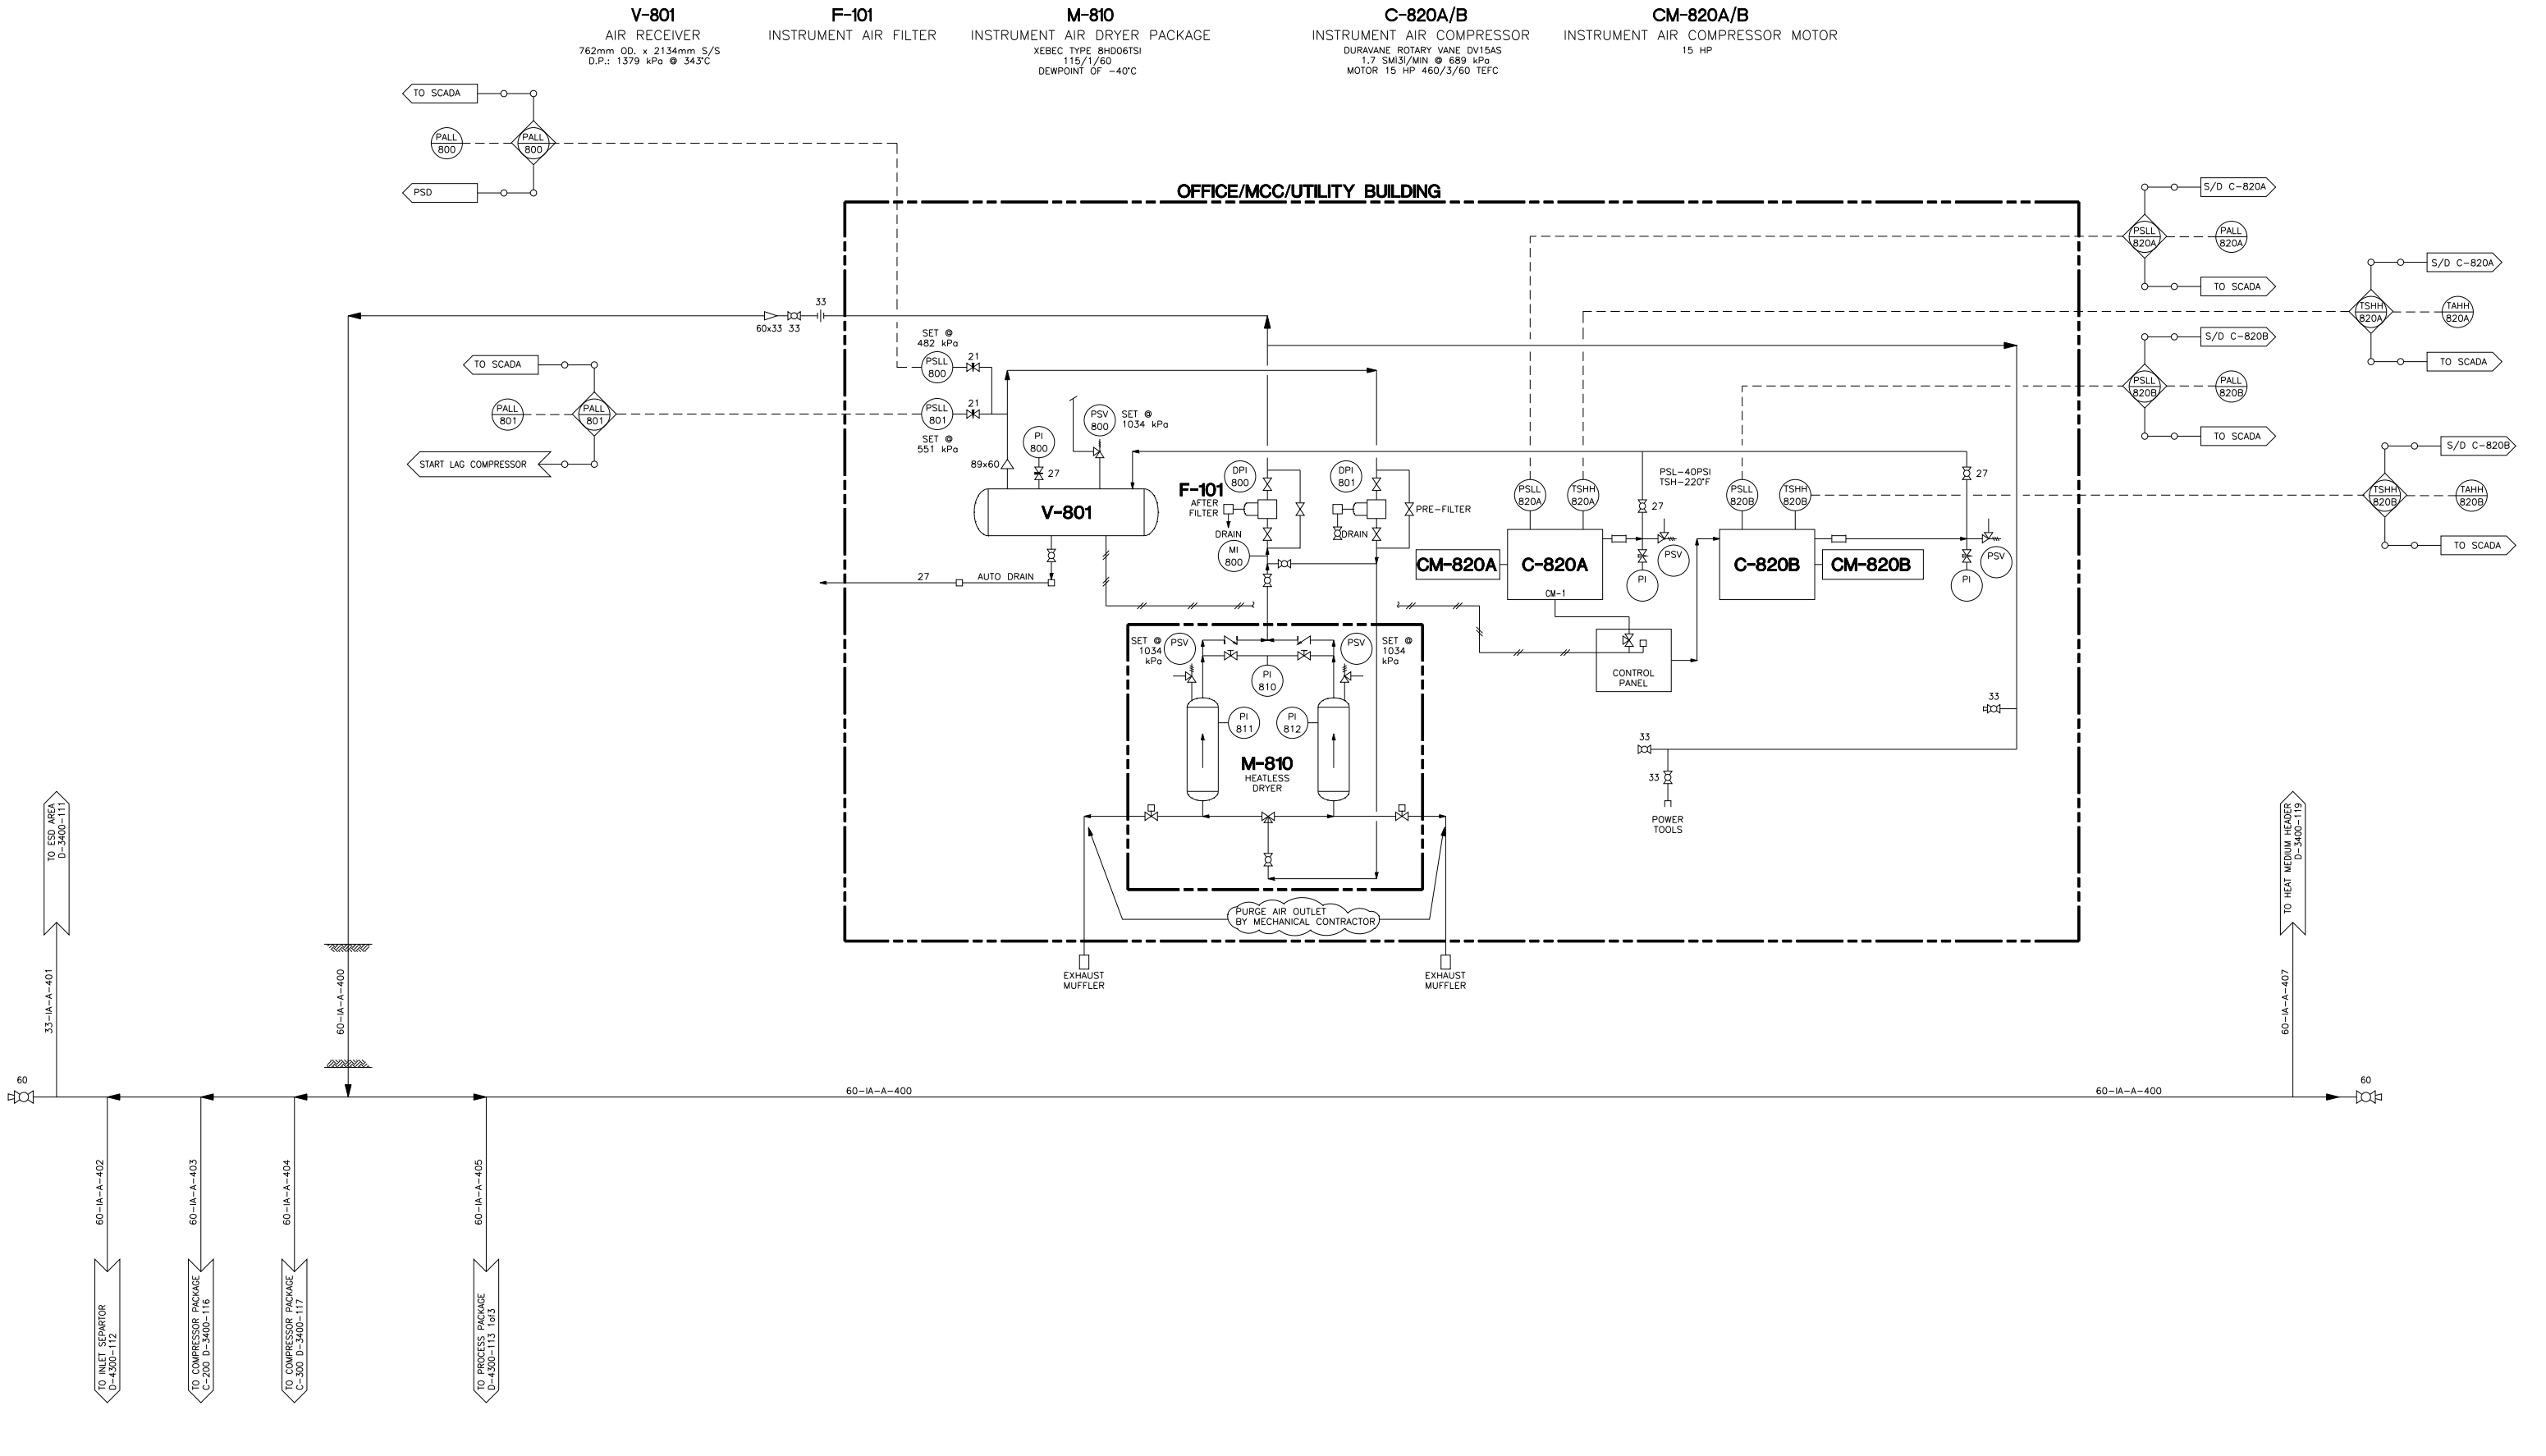

| DWG. NO. | REFERENCE DRAWINGS | REV | REVISIONS | DATE | BY | CHK'D | APP'D | AXL APP'D | ENGINEER AND PERMIT STAMPS | | | DESIGNED | DRAWN | 94-03-24 | PROJECT | | JOB NO. | | SCALE | DWG. NO. | 1 |
|----------|--------------------|-----|----------------------------|----------|-----|-------|-------|-----------|----------------------------|--|--|----------|---------|----------|--|--|---------|--|--------|------------|---|
| | | 1 | AS BUILT | 94-12-12 | TL | | | | | | | | ALDRAFT | | ANDERSON EXPLORATION LTD. CALGARY, ALBERTA, CANADA | | 3400 | | N.T.S. | D-3400-120 | |
| | | 0 | ISSUED FOR CONSTRUCTION | 94-09-21 | CAE | | KOR | RLK | | | | | | | SADDLE HILLS GAS PLANT | | | | | | |
| | | D | ISSUED FOR TENDER | 94-09-01 | AC | | | | | | | | | | PIPING & INSTRUMENTATION DIAGRAM INSTRUMENT AIR SYSTEM S.E. 1/4-3-77-7 W6M | | | | | | |
| | | C | APPROVED | 94-05-22 | CAE | | | | | | | | | | | | | | | | |
| | | B | ISSUED FOR CLIENT APPROVAL | 94-05-30 | MFM | MI | | | | | | | | | | | | | | | |
| | | A | ISSUED FOR APPROVAL | 94-03-24 | VLW | | | | | | | | | | | | | | | | |

