

**F-495**  
PROPANE FILTER/DRYER  
SPROLAN C19212P  
D.P.: 1860 kPa @ 66°C


**V-490**  
PROPANE ACCUMULATOR  
914mm O.D. x 3048mm S/S  
D.P.: 1860 kPa @ -29/66°C  
C.A. 1.6mm

**E-501**  
PROPANE CONDENSER  
AIR X-CHANGER MODEL 72B-2H  
A.P.: 1860 kPa @ 71°C  
DUTY: 303.5 kW  
MOTOR: (2) 7 1/2 HP, 480/3/60 XP MOTORS

**E-511**  
CONDENSATE COOLER  
AIR X-CHANGER MODEL 72B-2H  
D.P.: 2756 kPa @ 260°C  
DUTY: 242 kW  
COMMON FRAME WITH E-501

**H-455**  
STABILIZER REBOILER  
TYPE: SALT BATH HEATER  
914mm OD. x 3657mm LG.  
COIL D.P. = 2756 kPa @ 260°C  
DUTY: 146.5 kW

**TK-400**  
GLYCOL DRAIN TANK  
TYPE: 240SW-2250 LITRE  
1254 OD. x 2005 LONG (FIBREGLASS)  
1 - 114mm MONITORING SYSTEM

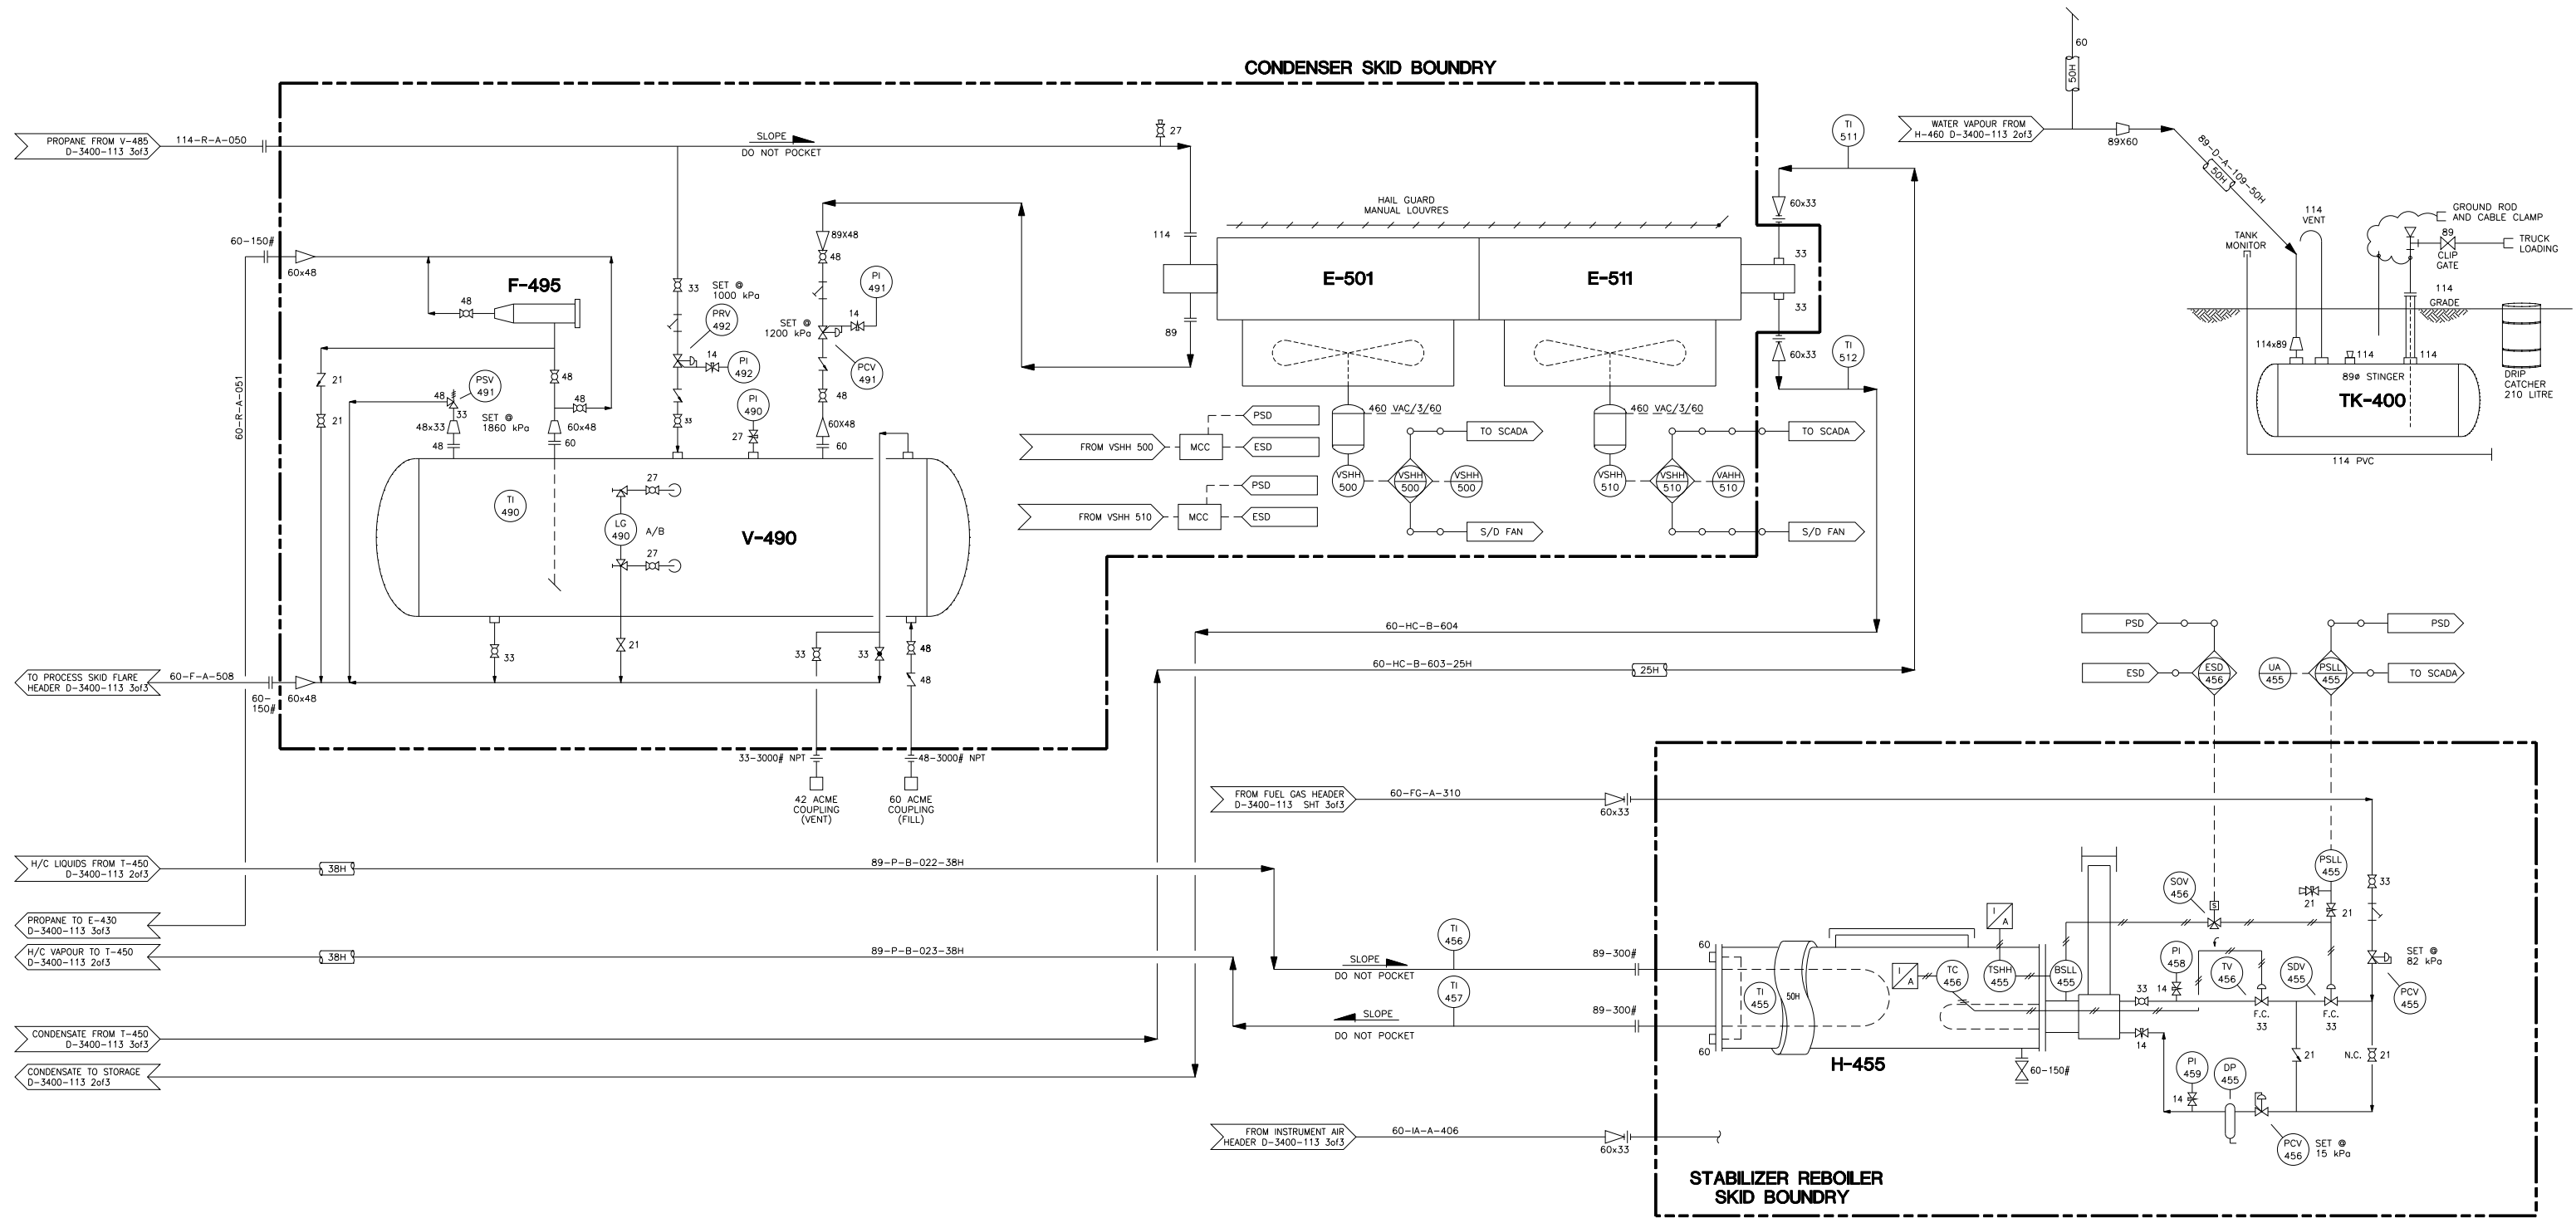

DWG. NO.	REFERENCE DRAWINGS	REV	REVISIONS	DATE	BY	CHK'D	APP'D	AXL APP'D	ENGINEER AND PERMIT STAMPS	DESIGNED	CHECKED	PROCESS CK.	MECH. CK.	STRUCT. CK.	ELECT. CK.	AXL APP.	AXL APP.	PROJECT	JOB NO.	SCALE	DWG. NO.	1
		1	AS BUILT	94-12-12	TL						ALDRAFT							(AXL) ANDERSON EXPLORATION LTD. CALGARY, ALBERTA, CANADA	3400	N.T.S.	D-3400-114	
		0	ISSUED FOR CONSTRUCTION	94-09-21	CAE		KOR	RLK										PROJECT				
		D	ISSUED FOR TENDER	94-09-01	AC													SADDLE HILLS GAS PLANT				
		C	APPROVED	94-07-22	CAE													PIPING & INSTRUMENTATION DIAGRAM PRODUCT COOLER / STABILIZER REBOILER S.E. 1/4-3-77-7 W6M				
		B	ISSUED FOR CLIENT APPROVAL	94-05-30	MFM	MI																
		A	ISSUED FOR APPROVAL	94-03-24	VLW																	

